




PREFAB E

Innovation space



<p>KEY PLAN</p> 	<p>Client</p> 	<p>Consultant</p> <p>German Jordanian University</p> <p>AMMAN — JORDAN</p>
---	---	--

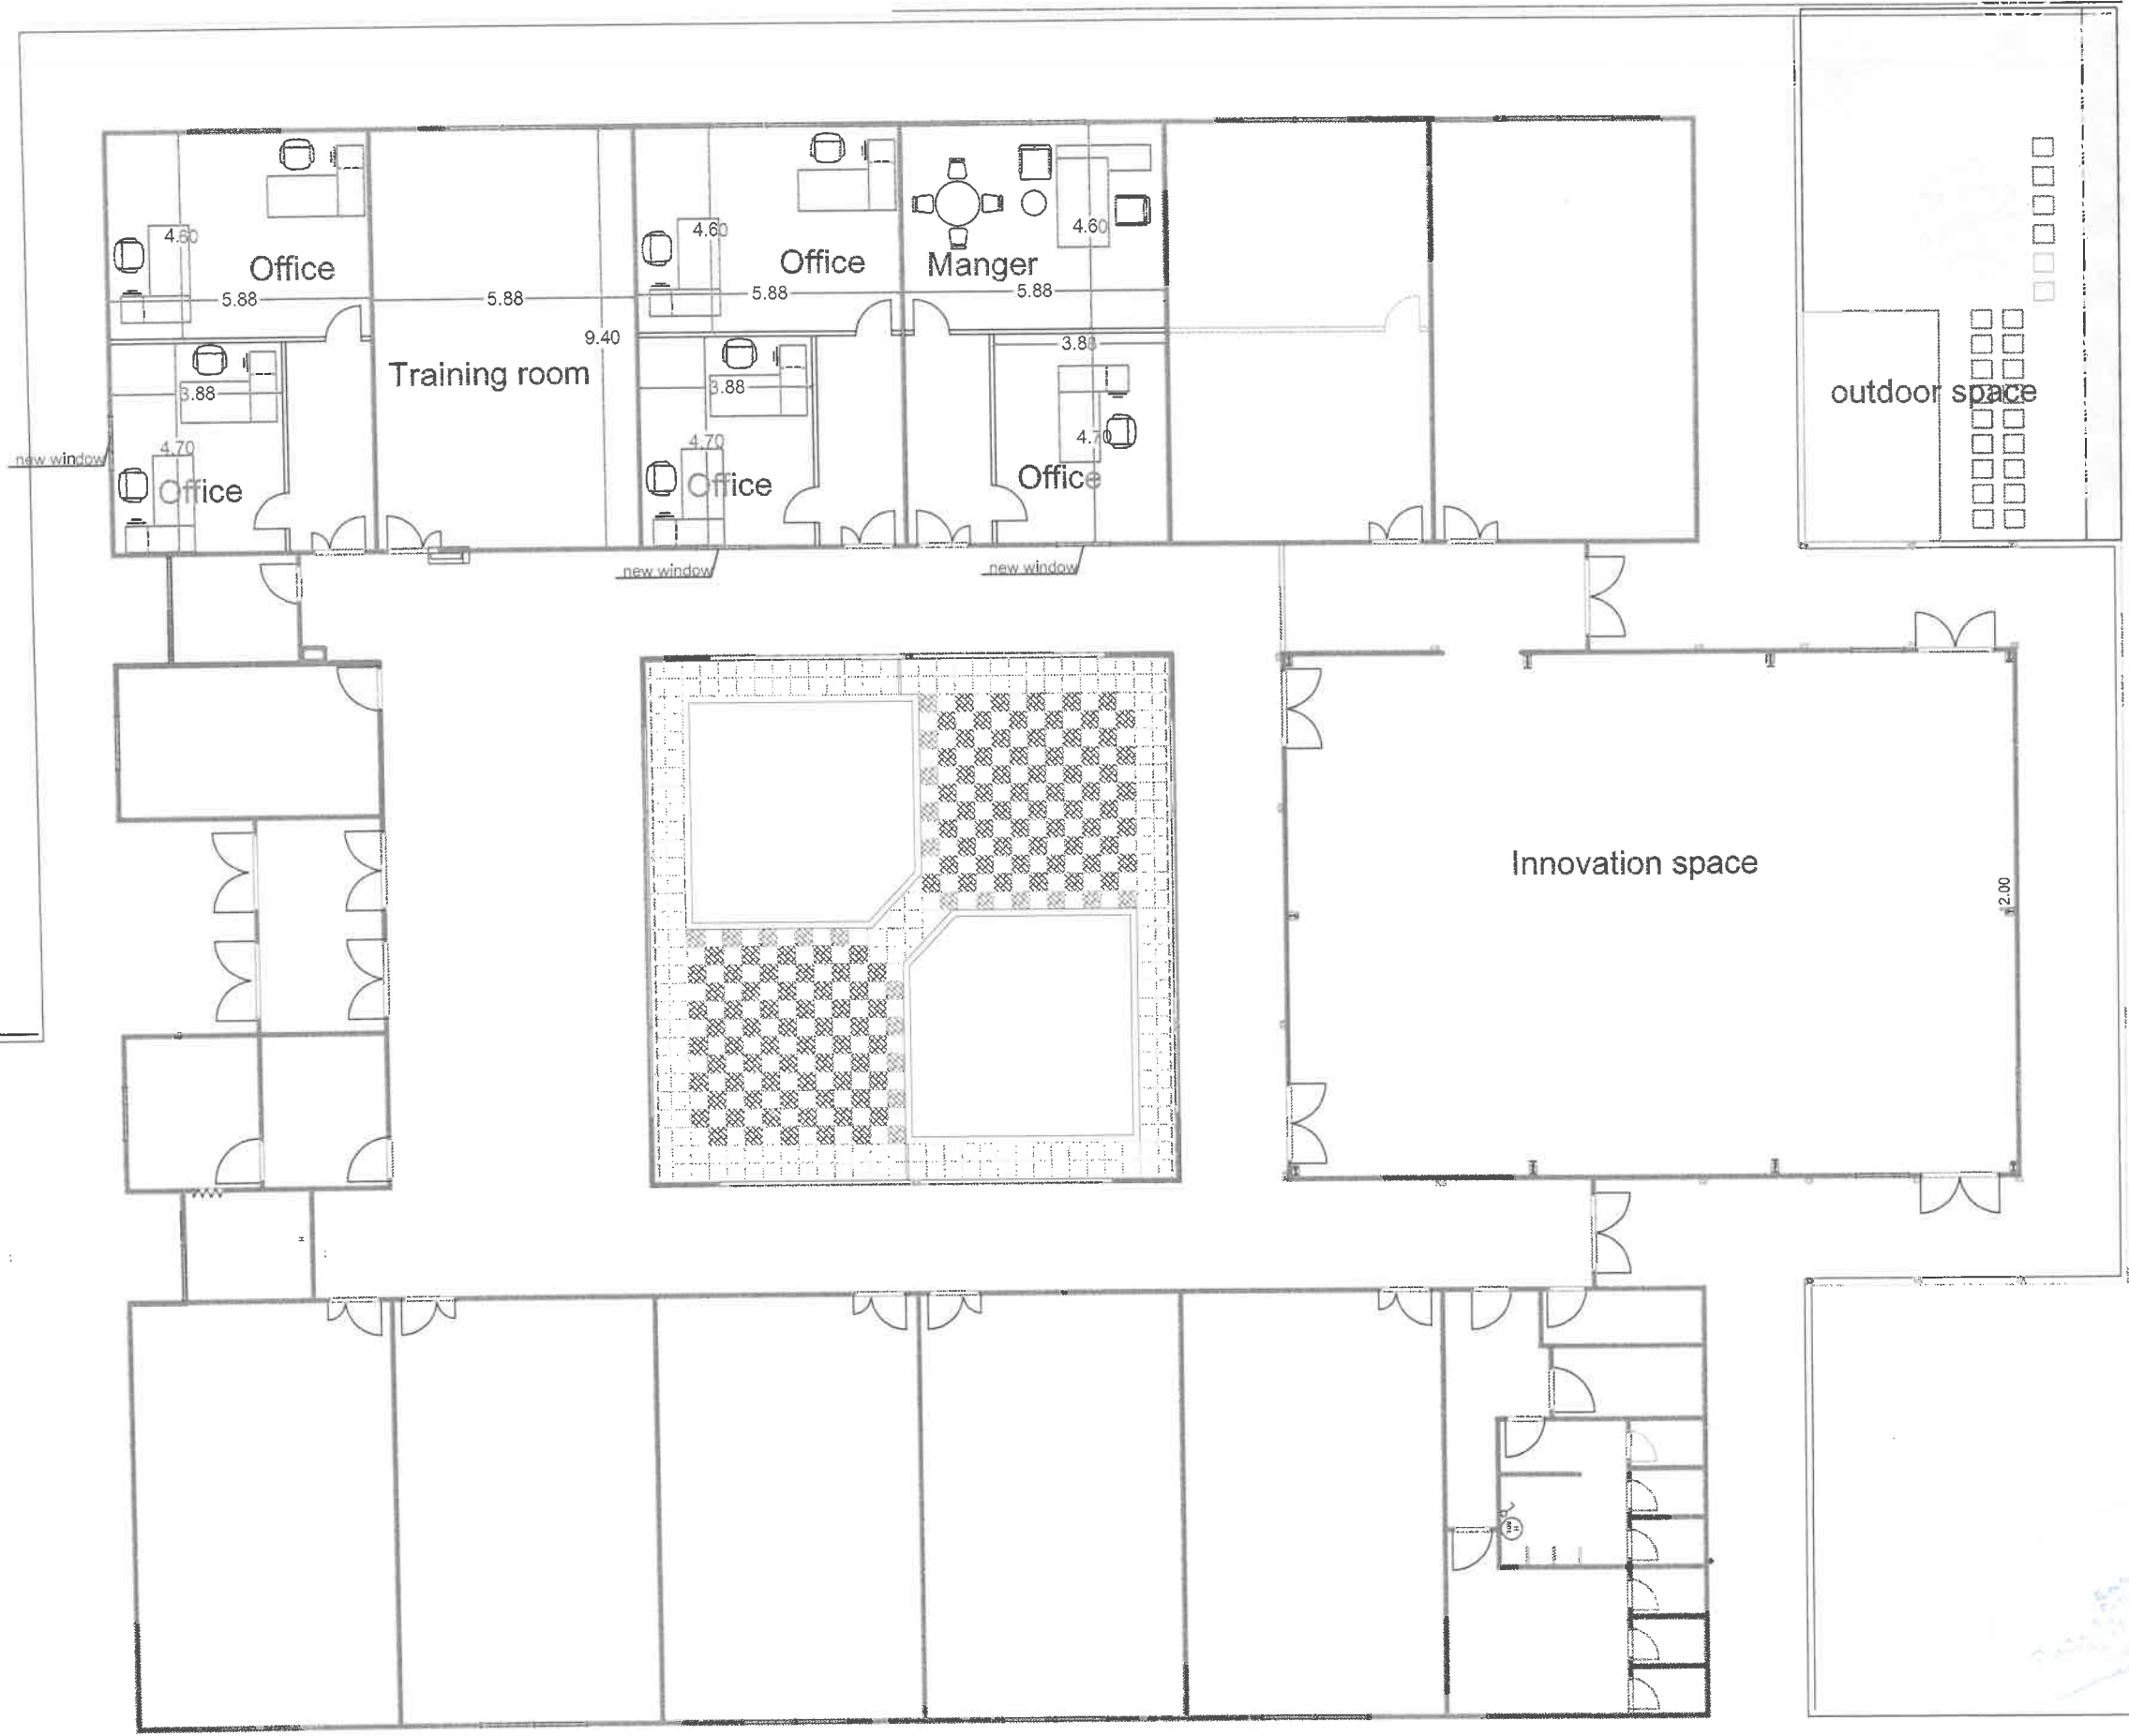


PRODUCED BY AN AUTODESK STUDENT VERSION

PRODUCED BY AN AUTODESK STUDENT VERSION





Client
 Consultant
GJU
 German Jordanian University
 الجامعة الألمانية الأردنية
 German Jordanian University
 AMMAN - JORDAN

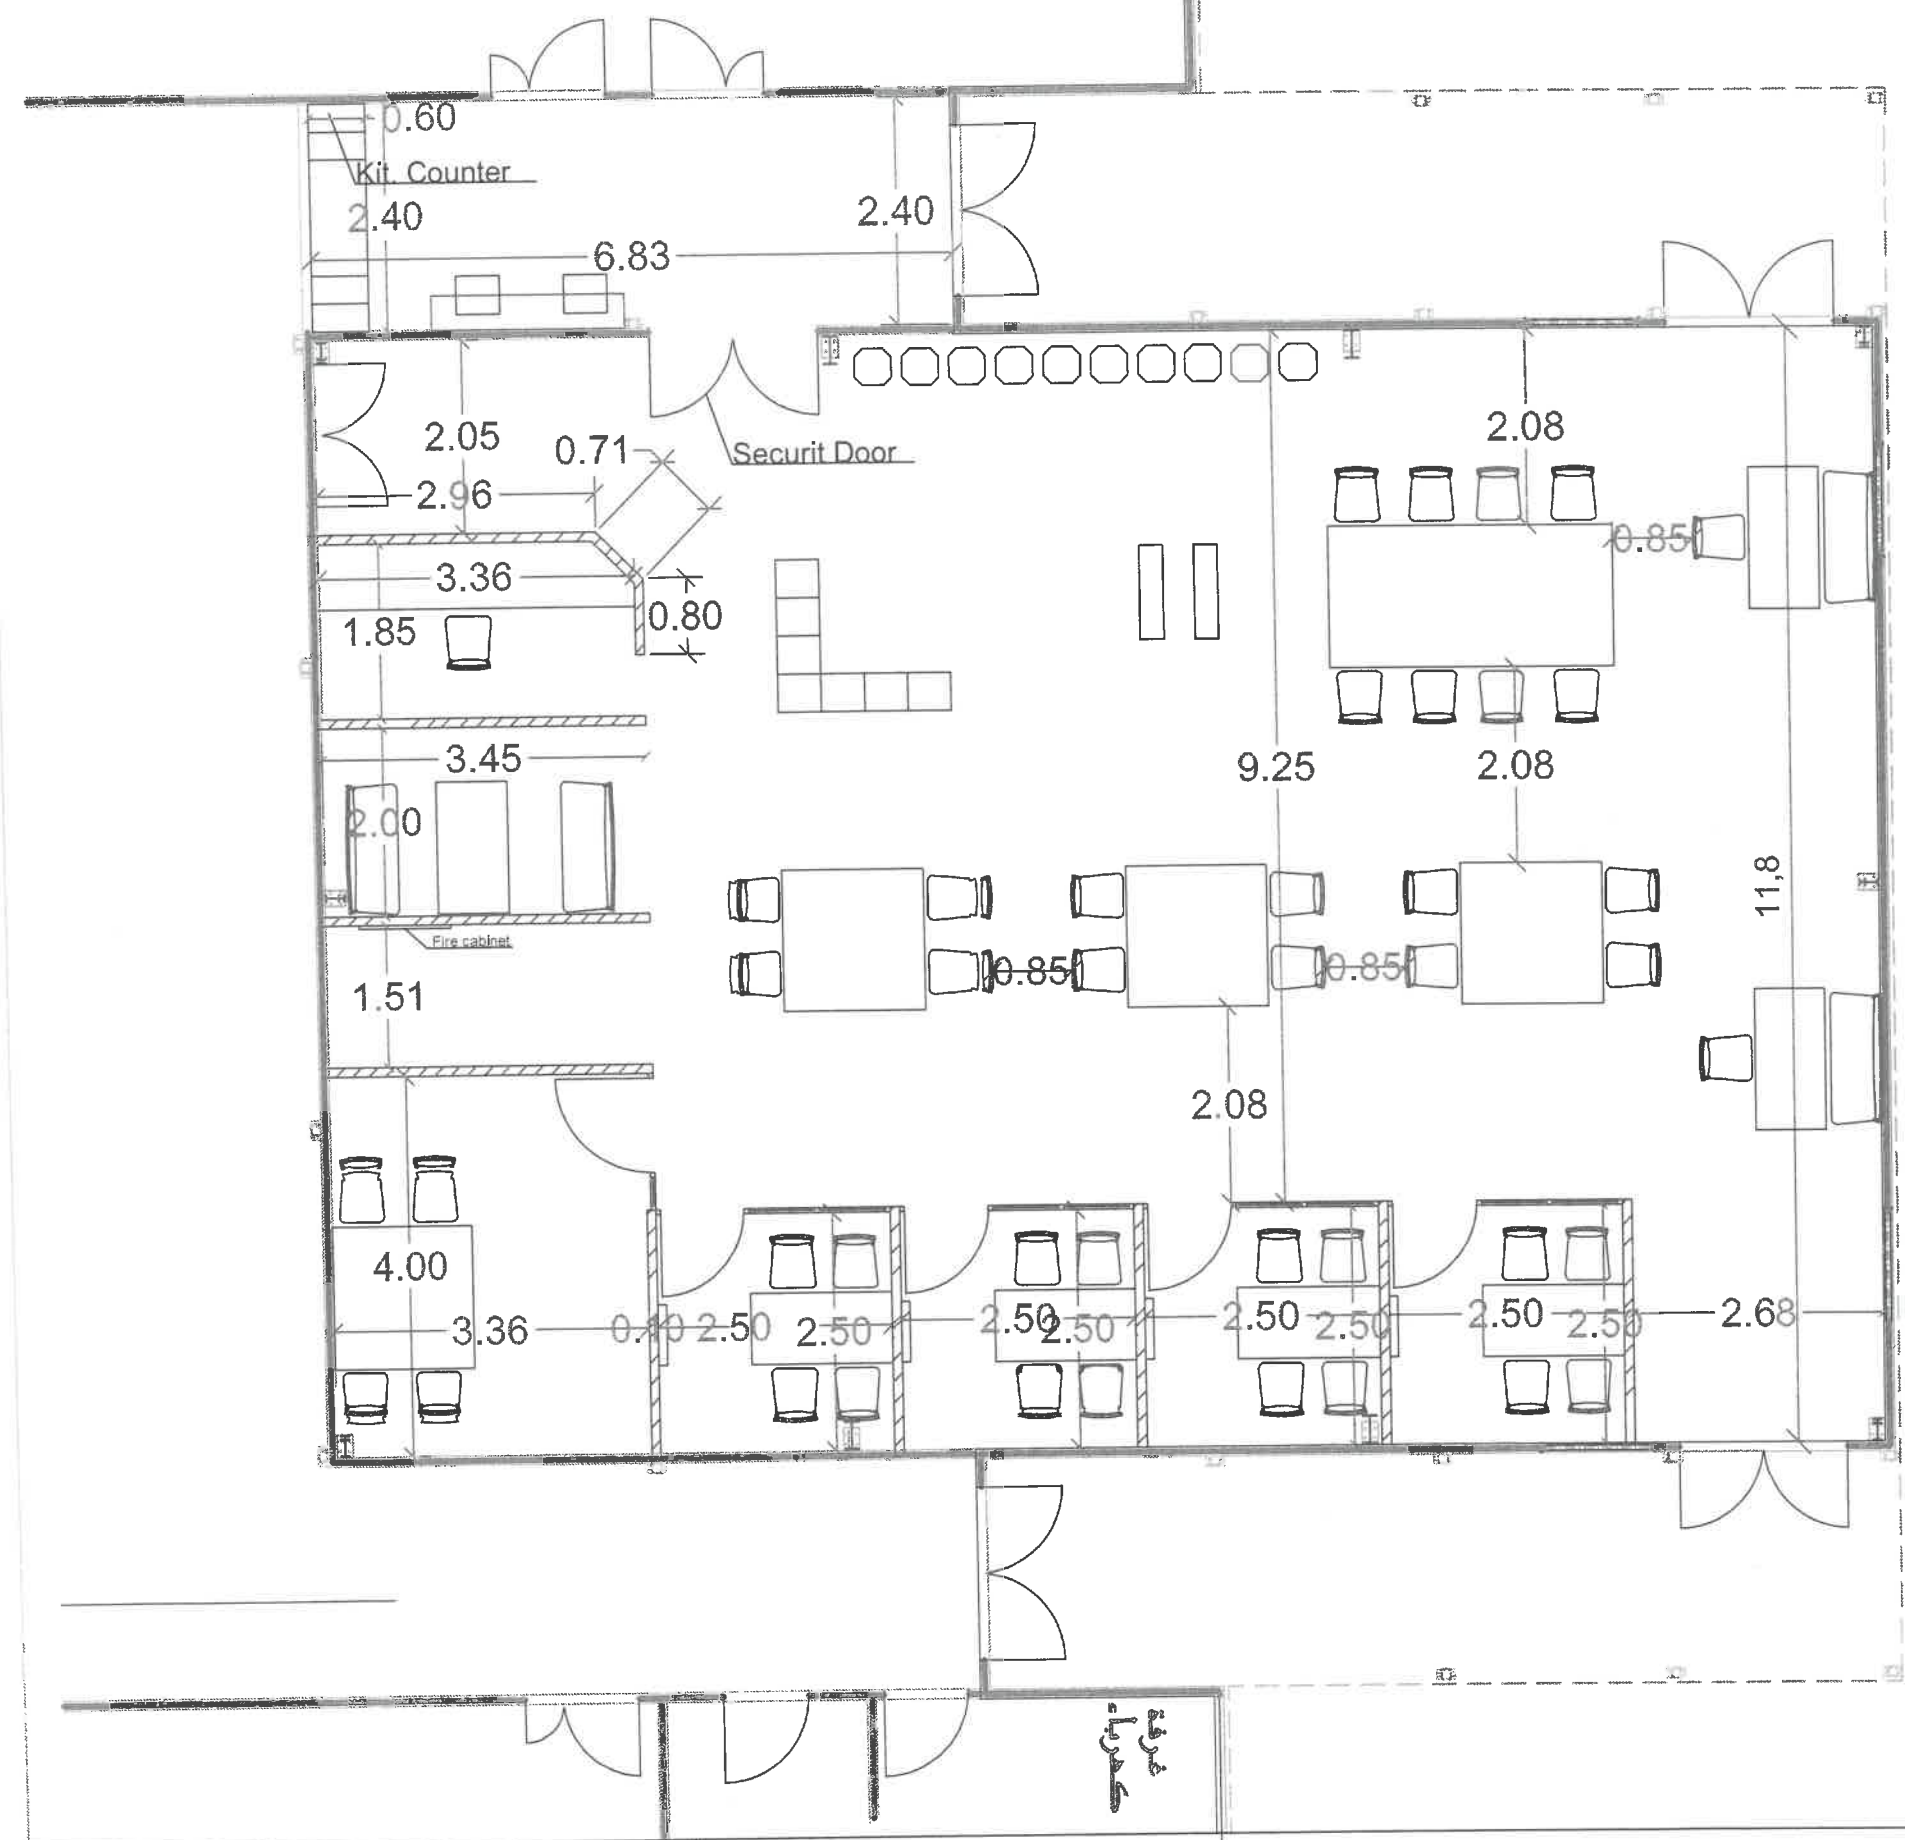PREFAB E
 Gypsum board Partitions
 Scale
 N.T.S
 A01




LEGEND :





-  PROPOSED PARTITION
-  PROPOSED GLASS PARTITION

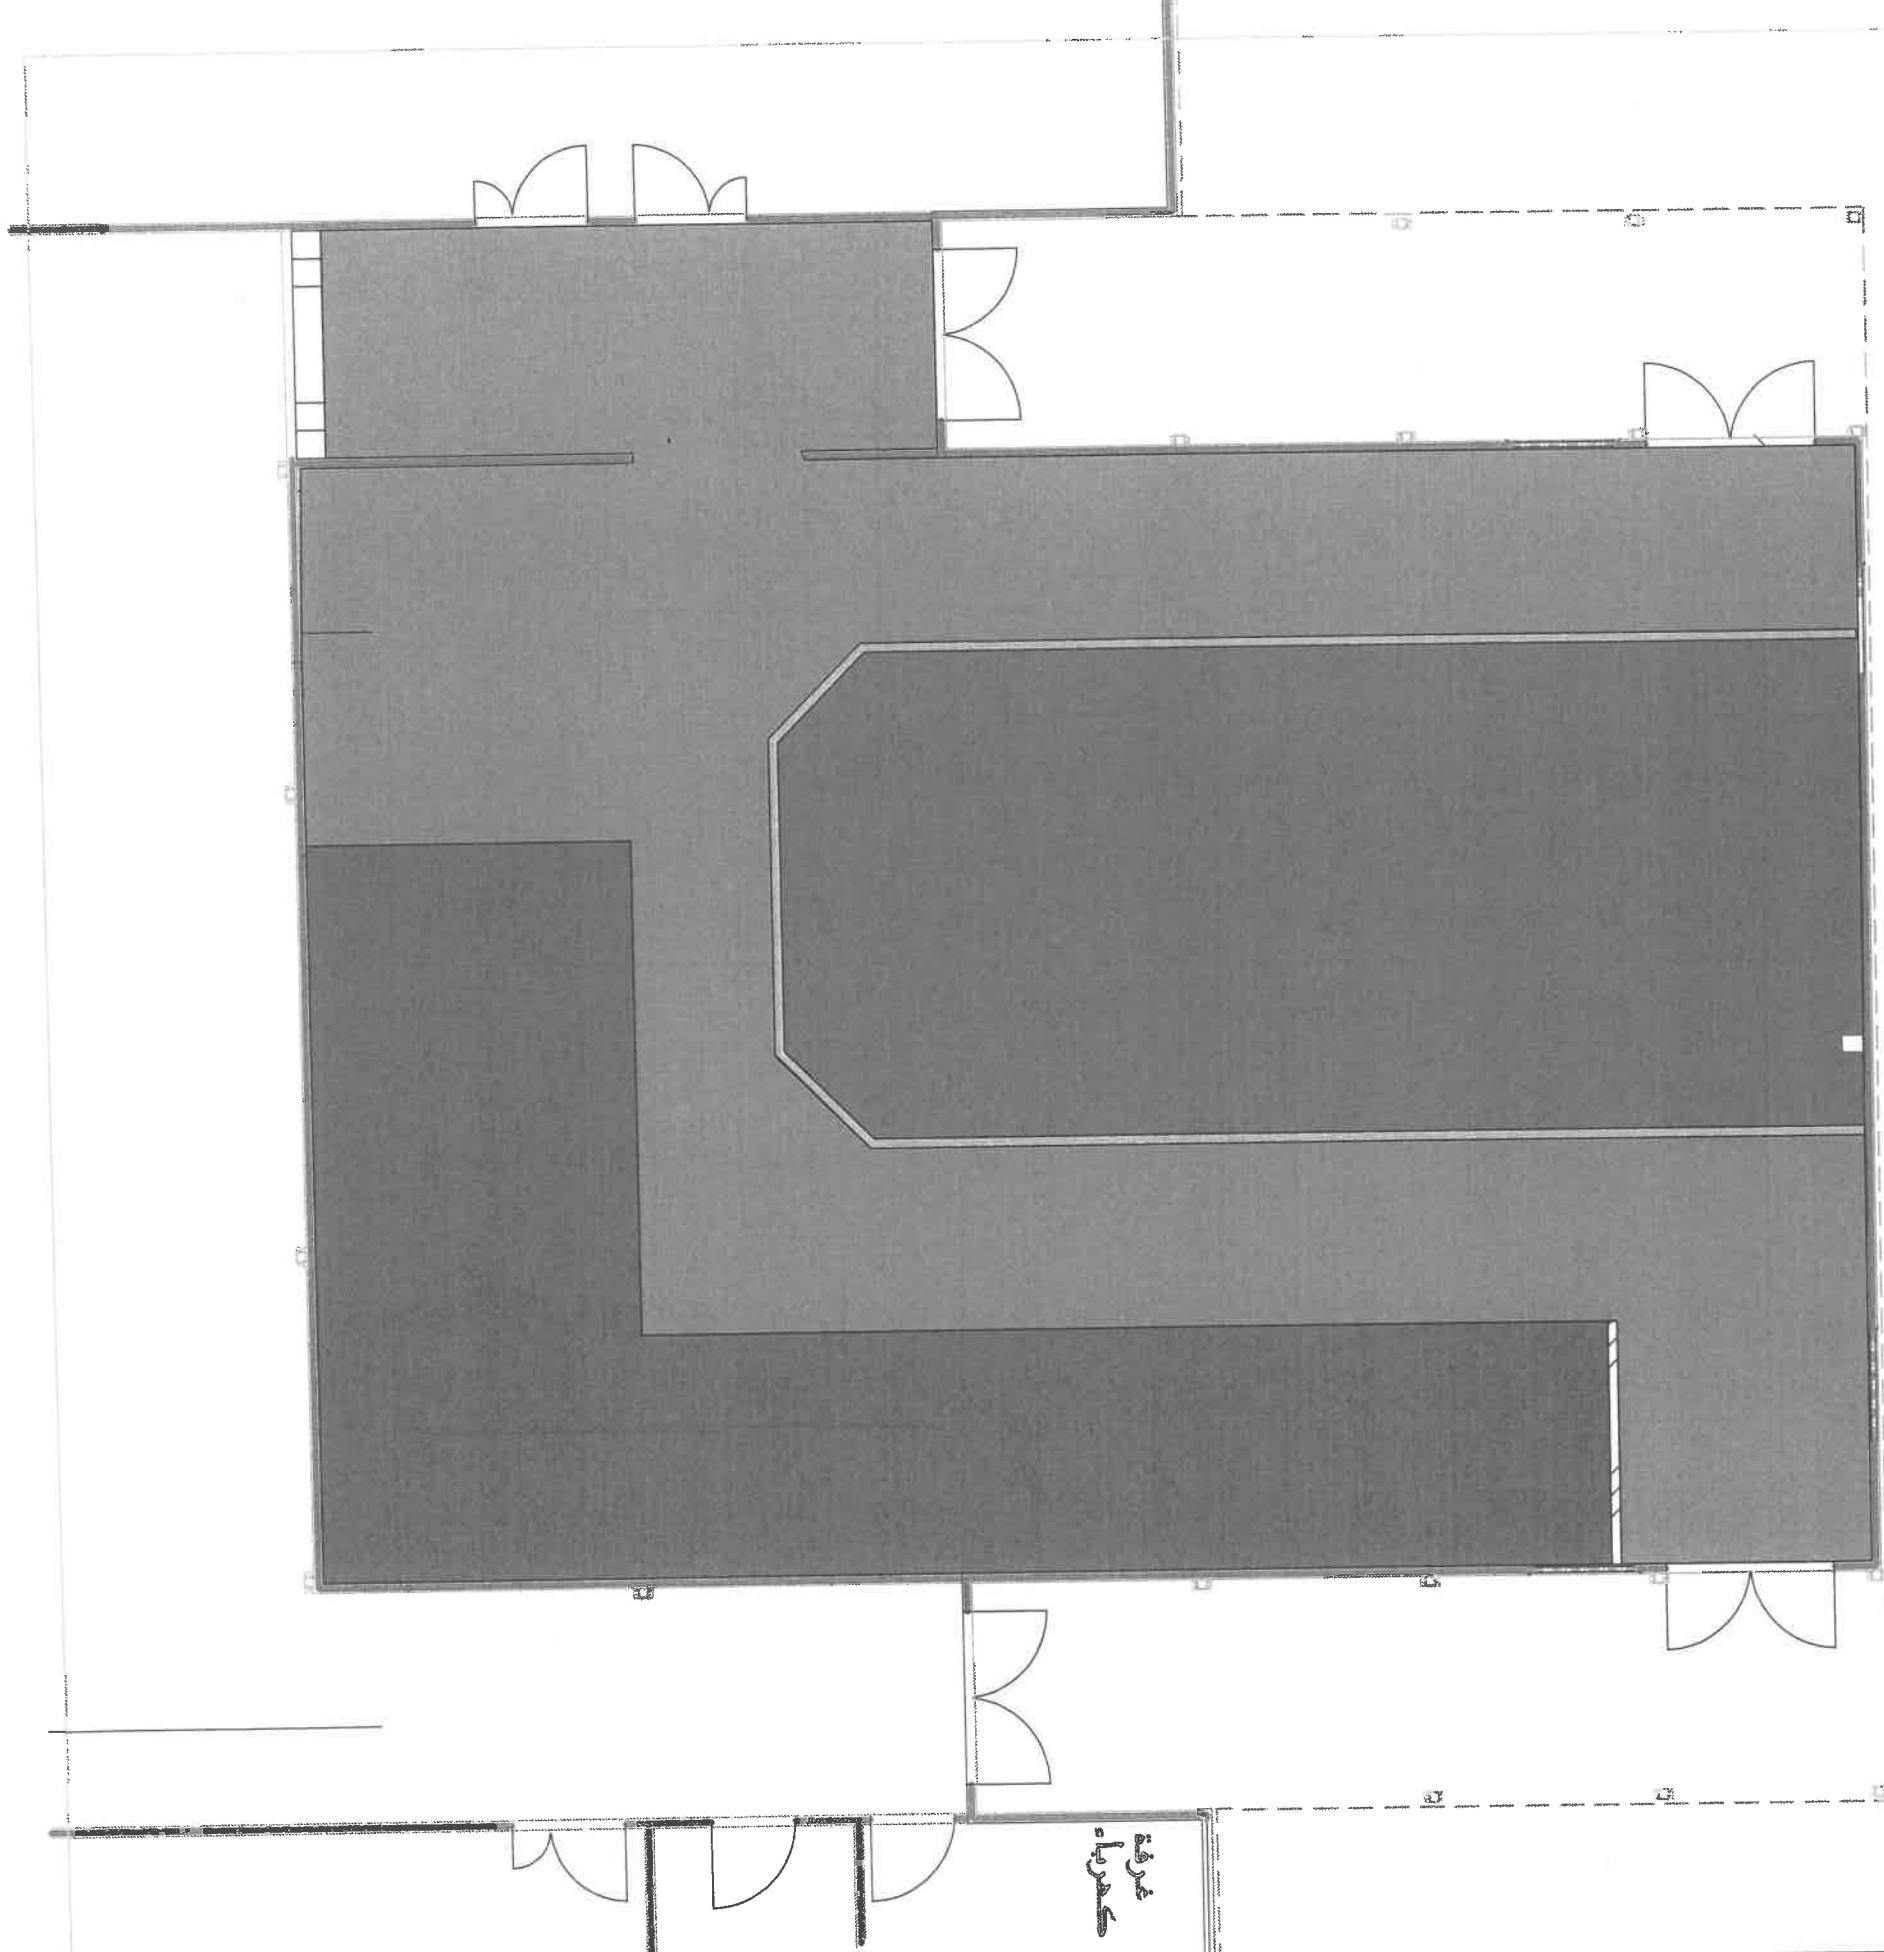KEY PLAN	Client	Consultant
	 German Jordanian University الجامعة الألمانية الأردنية German Jordanian University	German Jordanian University AMMAN - JORDAN

PREFAB E Innovation space	Scale N.T.S	A02
------------------------------	----------------	-----



FLOORS



	61	M2
	3	M2
	53	M2
	96	M2



Client
GJU
 الجامعة الألمانية الأردنية
 German Jordanian University
 AMMAN - JORDAN

Consultant
 German Jordanian
 University
 AMMAN - JORDAN

PREFAB E
 Innovation space
 Scale
 N.T.S
 A03

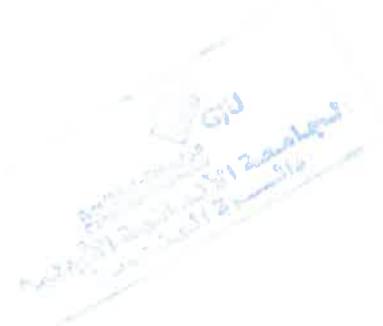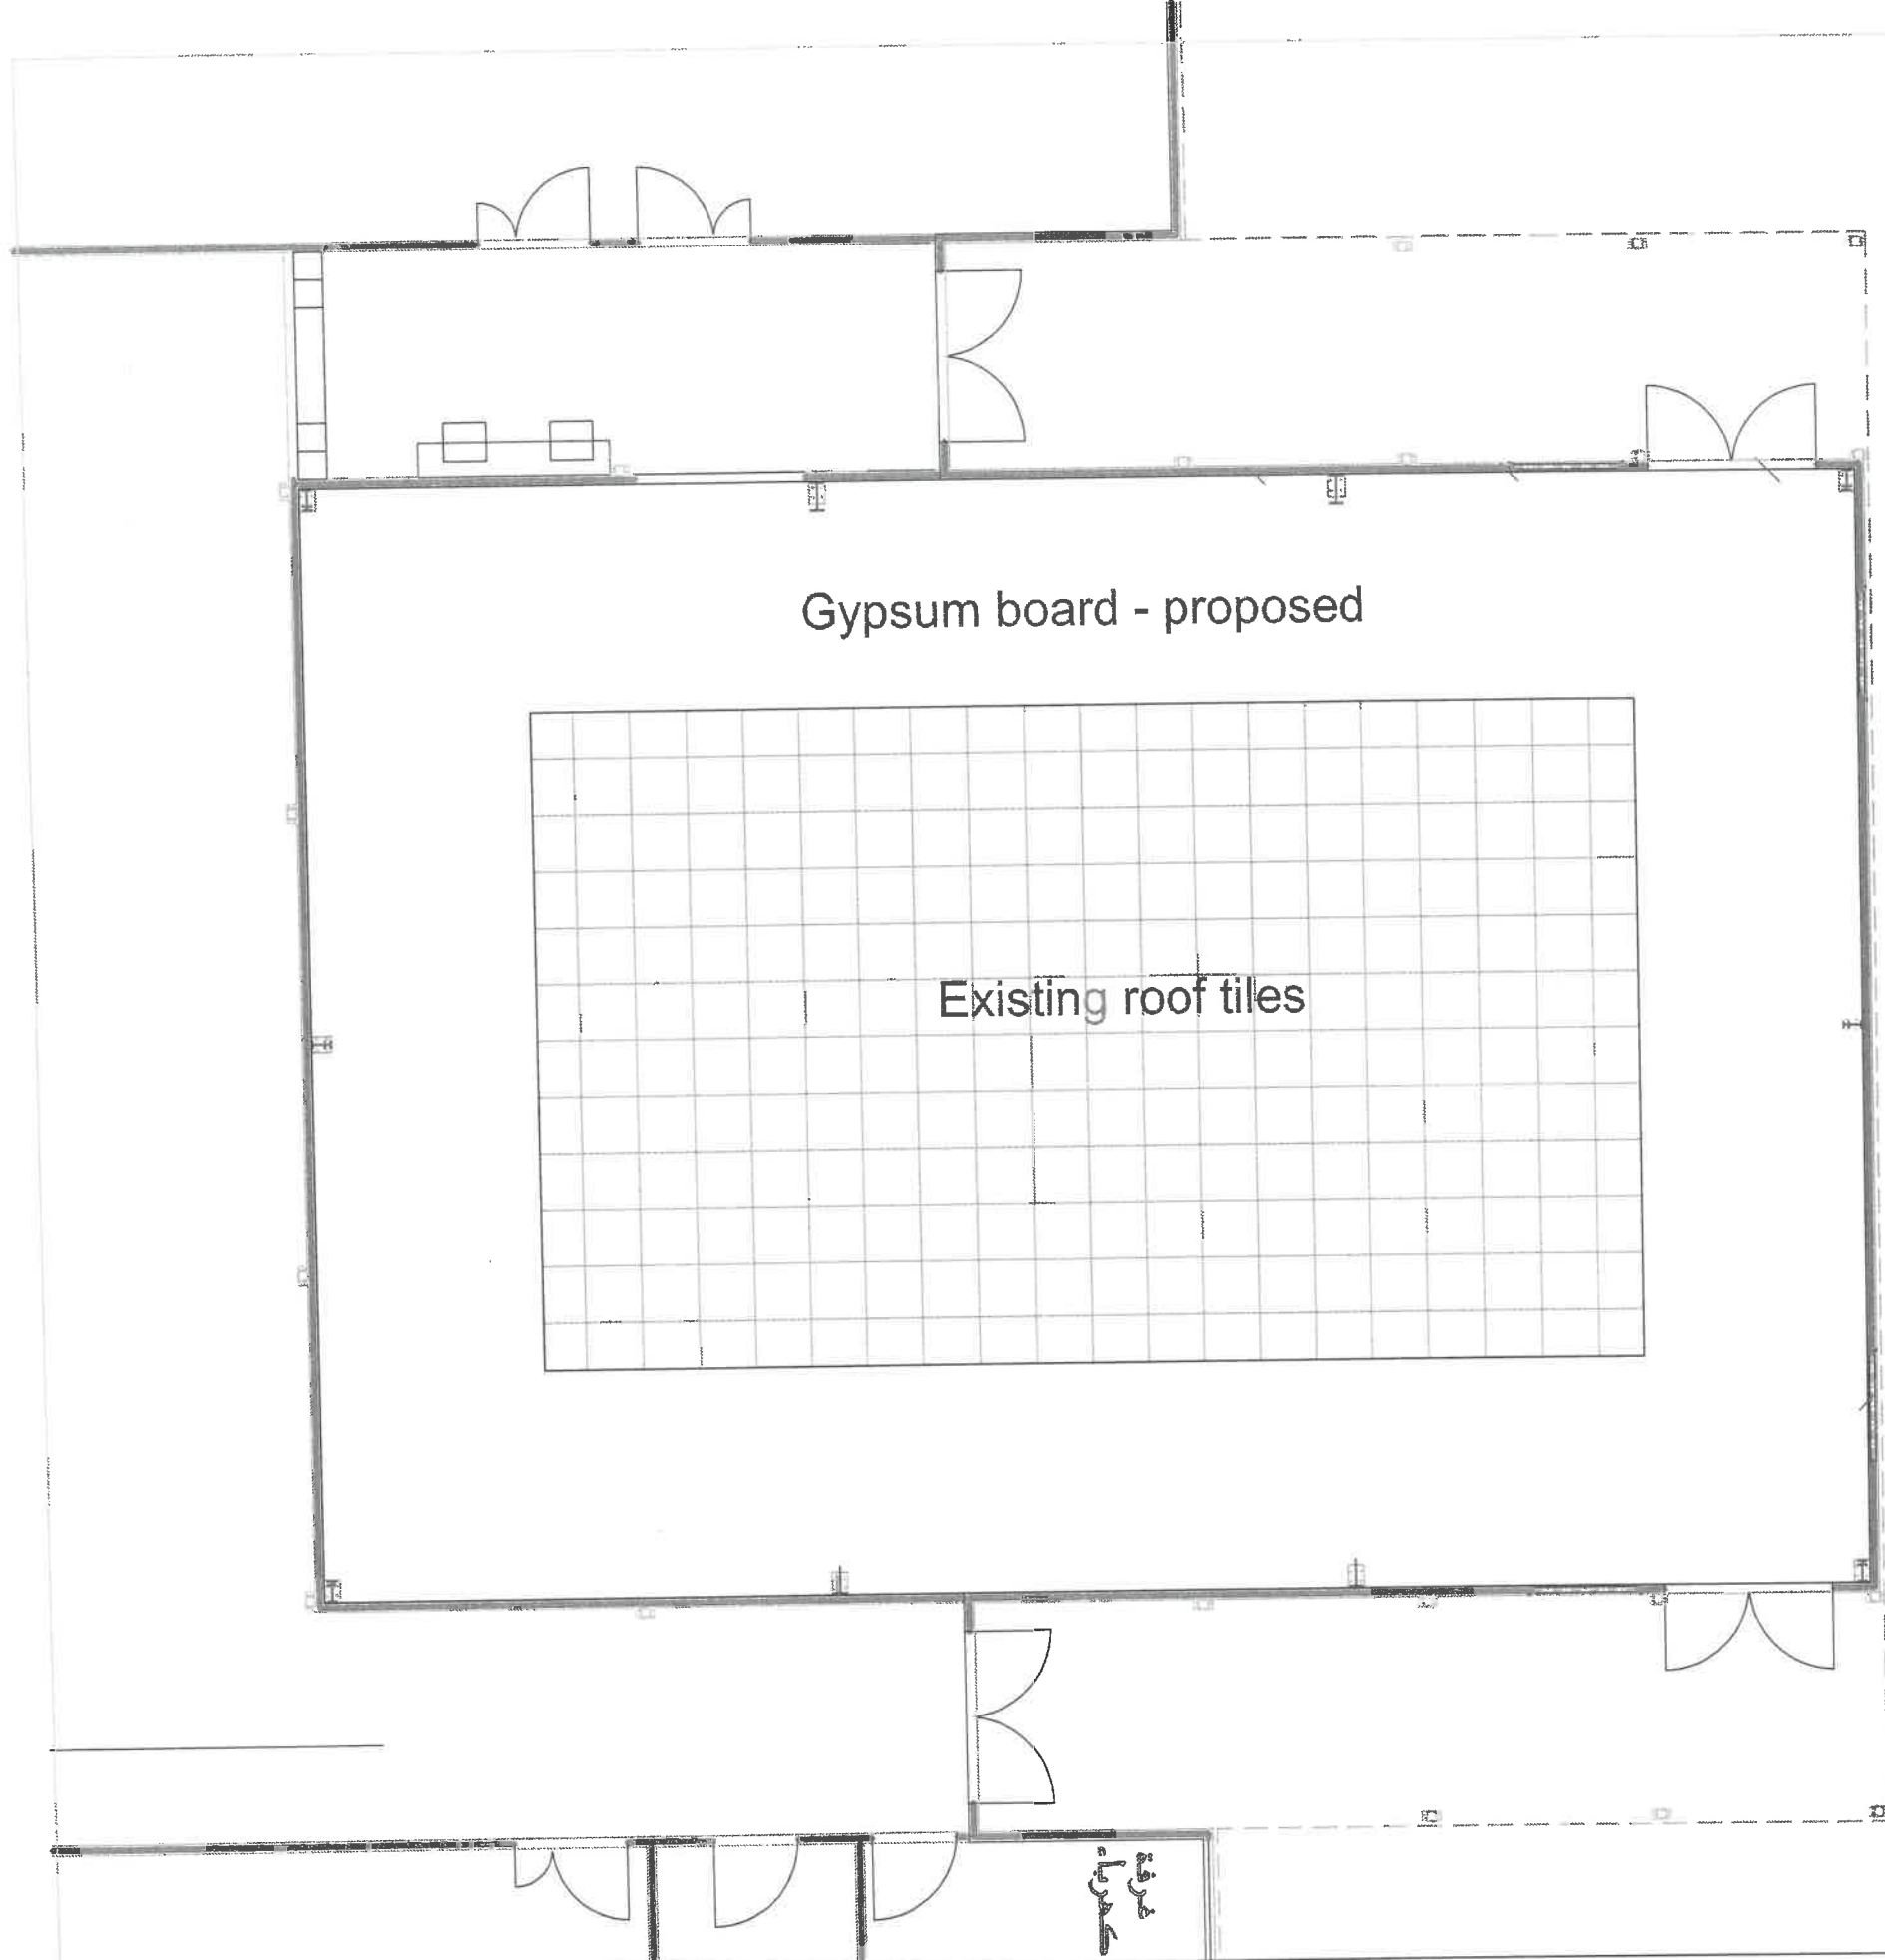

KEY PLAN



Client




Consultant
 German Jordanian University
 AMMAN - JORDAN

PREFAB E
 Innovation space

Scale
 N.T.S

A04

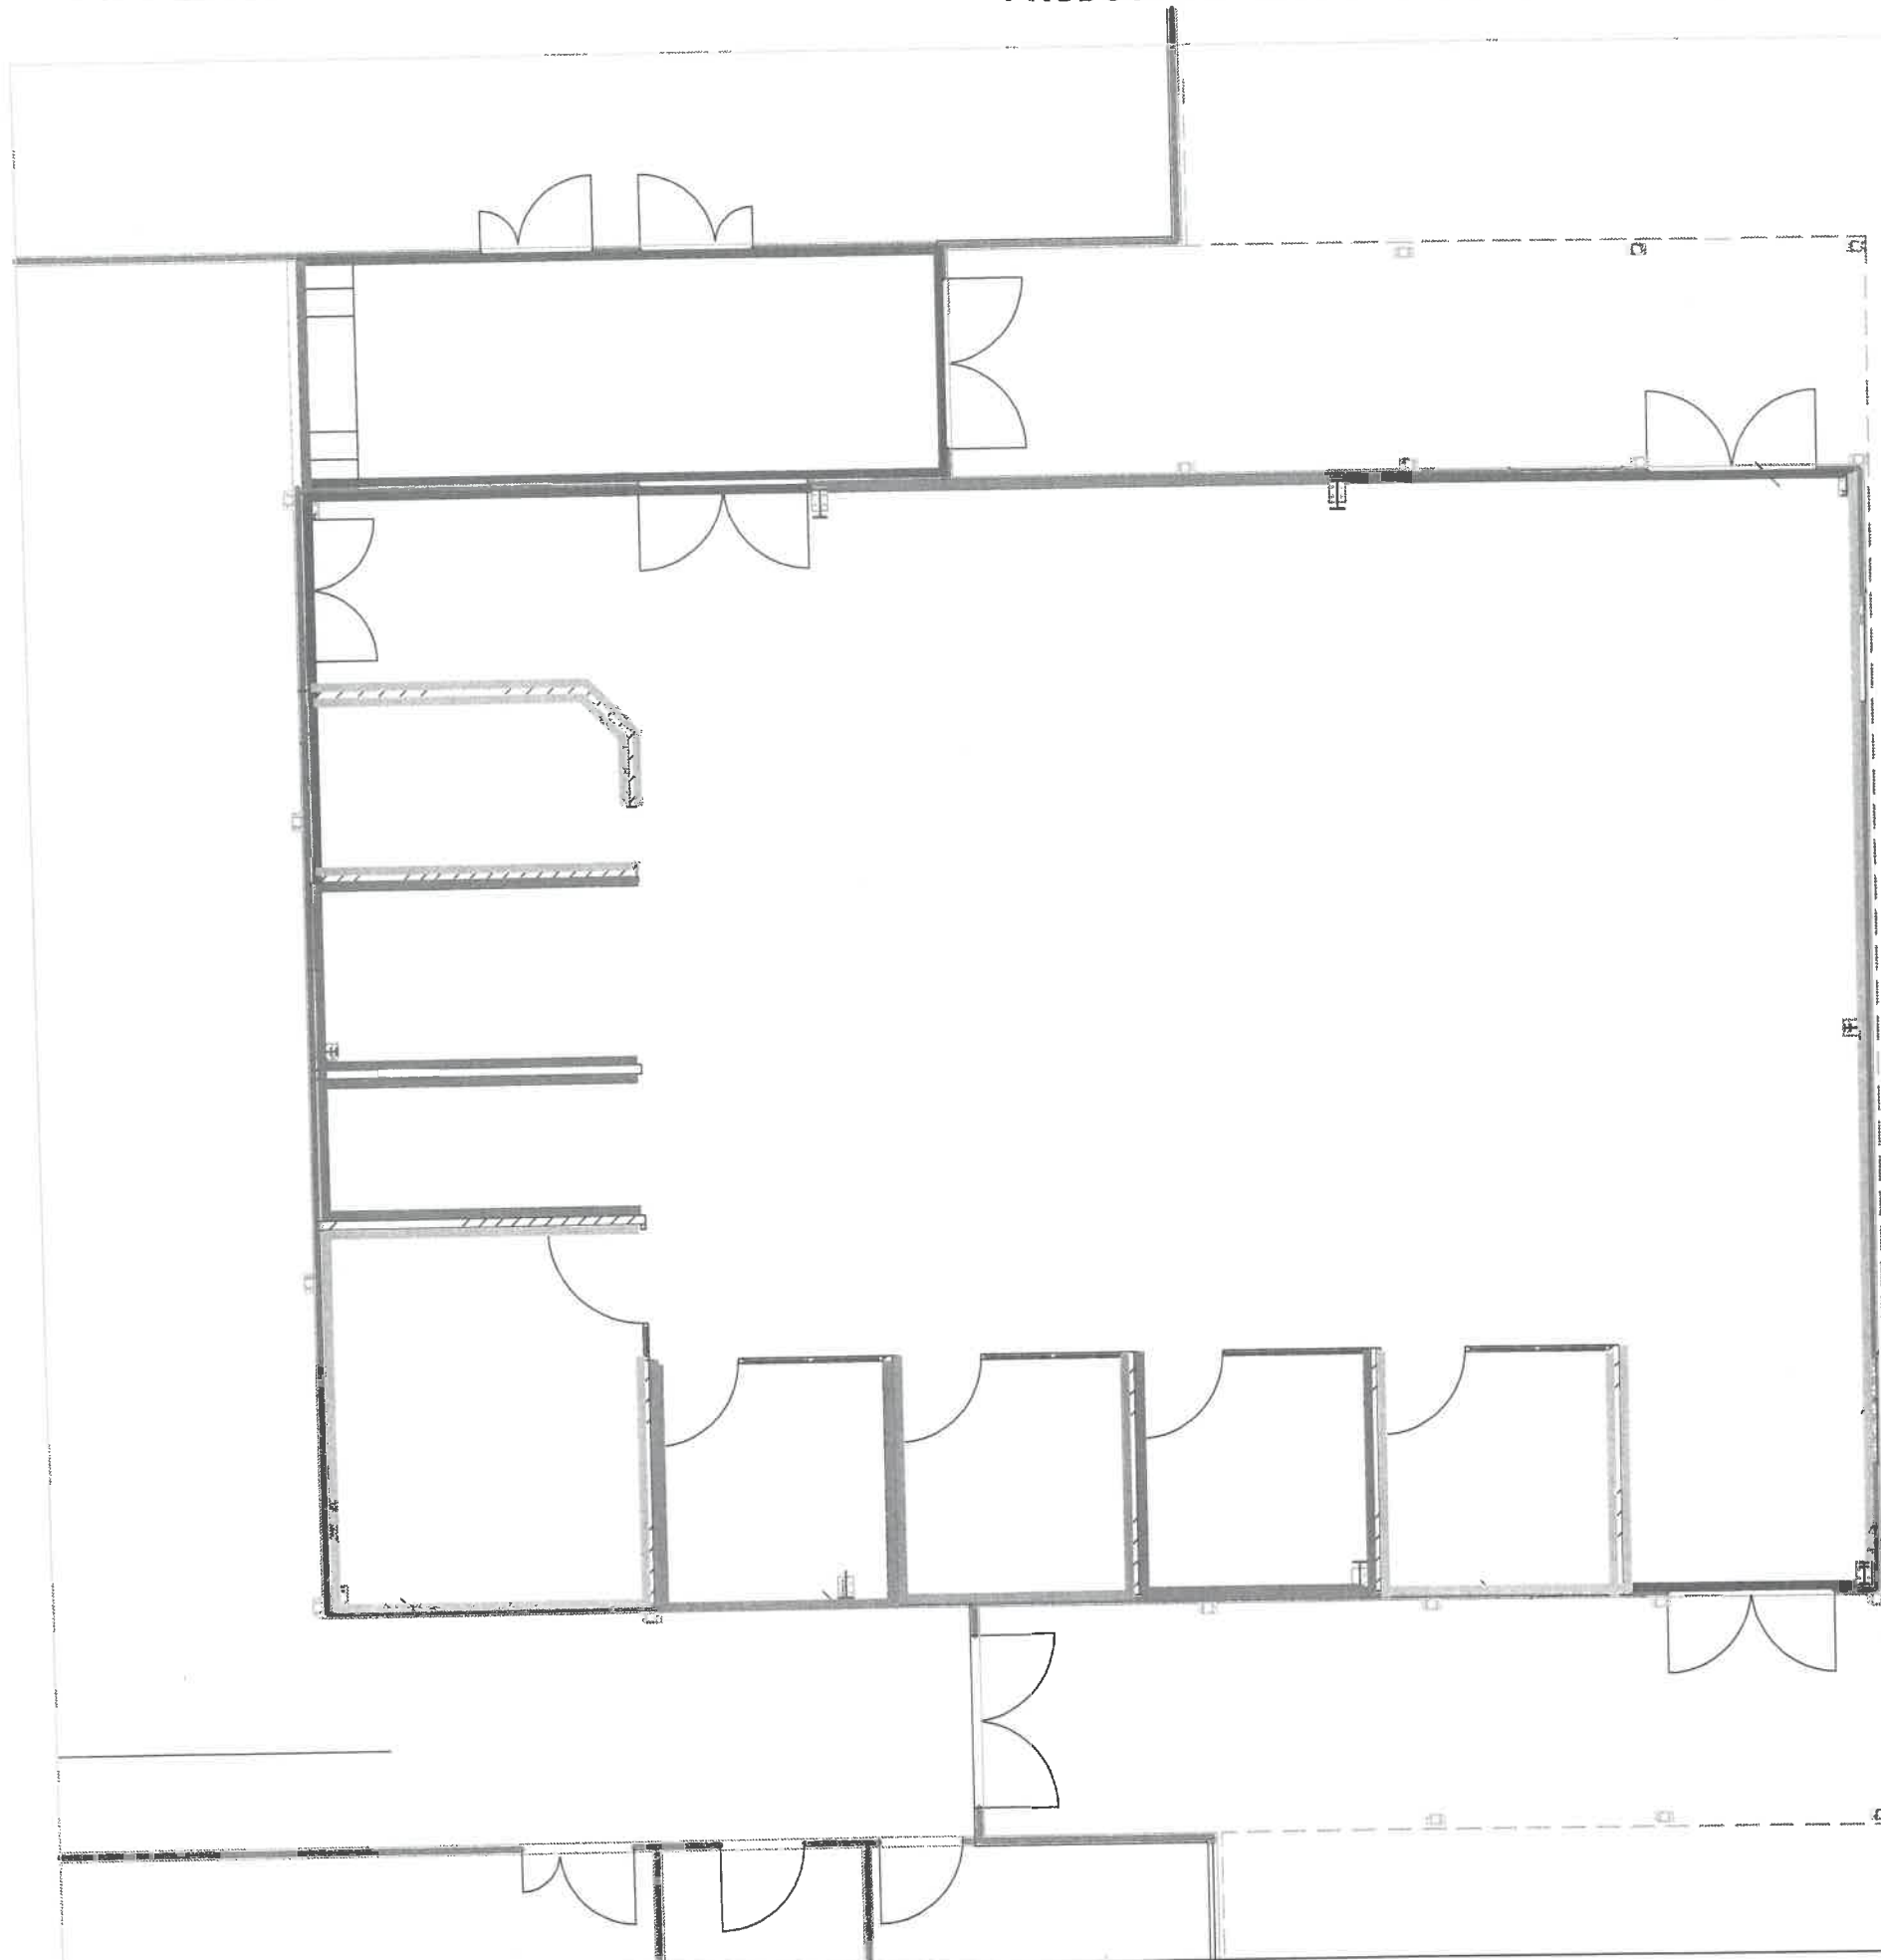

Walls coverings

- (White)
-
-
-
-
-
-



Client
GJU
 German Jordanian University
 الجامعة الألمانية الأردنية
 German Jordanian University
 AMMAN - JORDAN

Consultant
 German Jordanian University
 AMMAN - JORDAN

PREFAB E Innovation space	Scale N.T.S	A05
------------------------------	----------------	-----




PRODUCED BY AN AUTODESK STUDENT VERSION

PRODUCED BY AN AUTODESK STUDENT VERSION




Client
GJU
 الجامعة الألمانية الأردنية
 German Jordanian University
 Consultant
 German Jordanian University
 AMMAN - JORDAN

PREFAB E
 Ventilation System
 Scale
 N.T.S
 M01

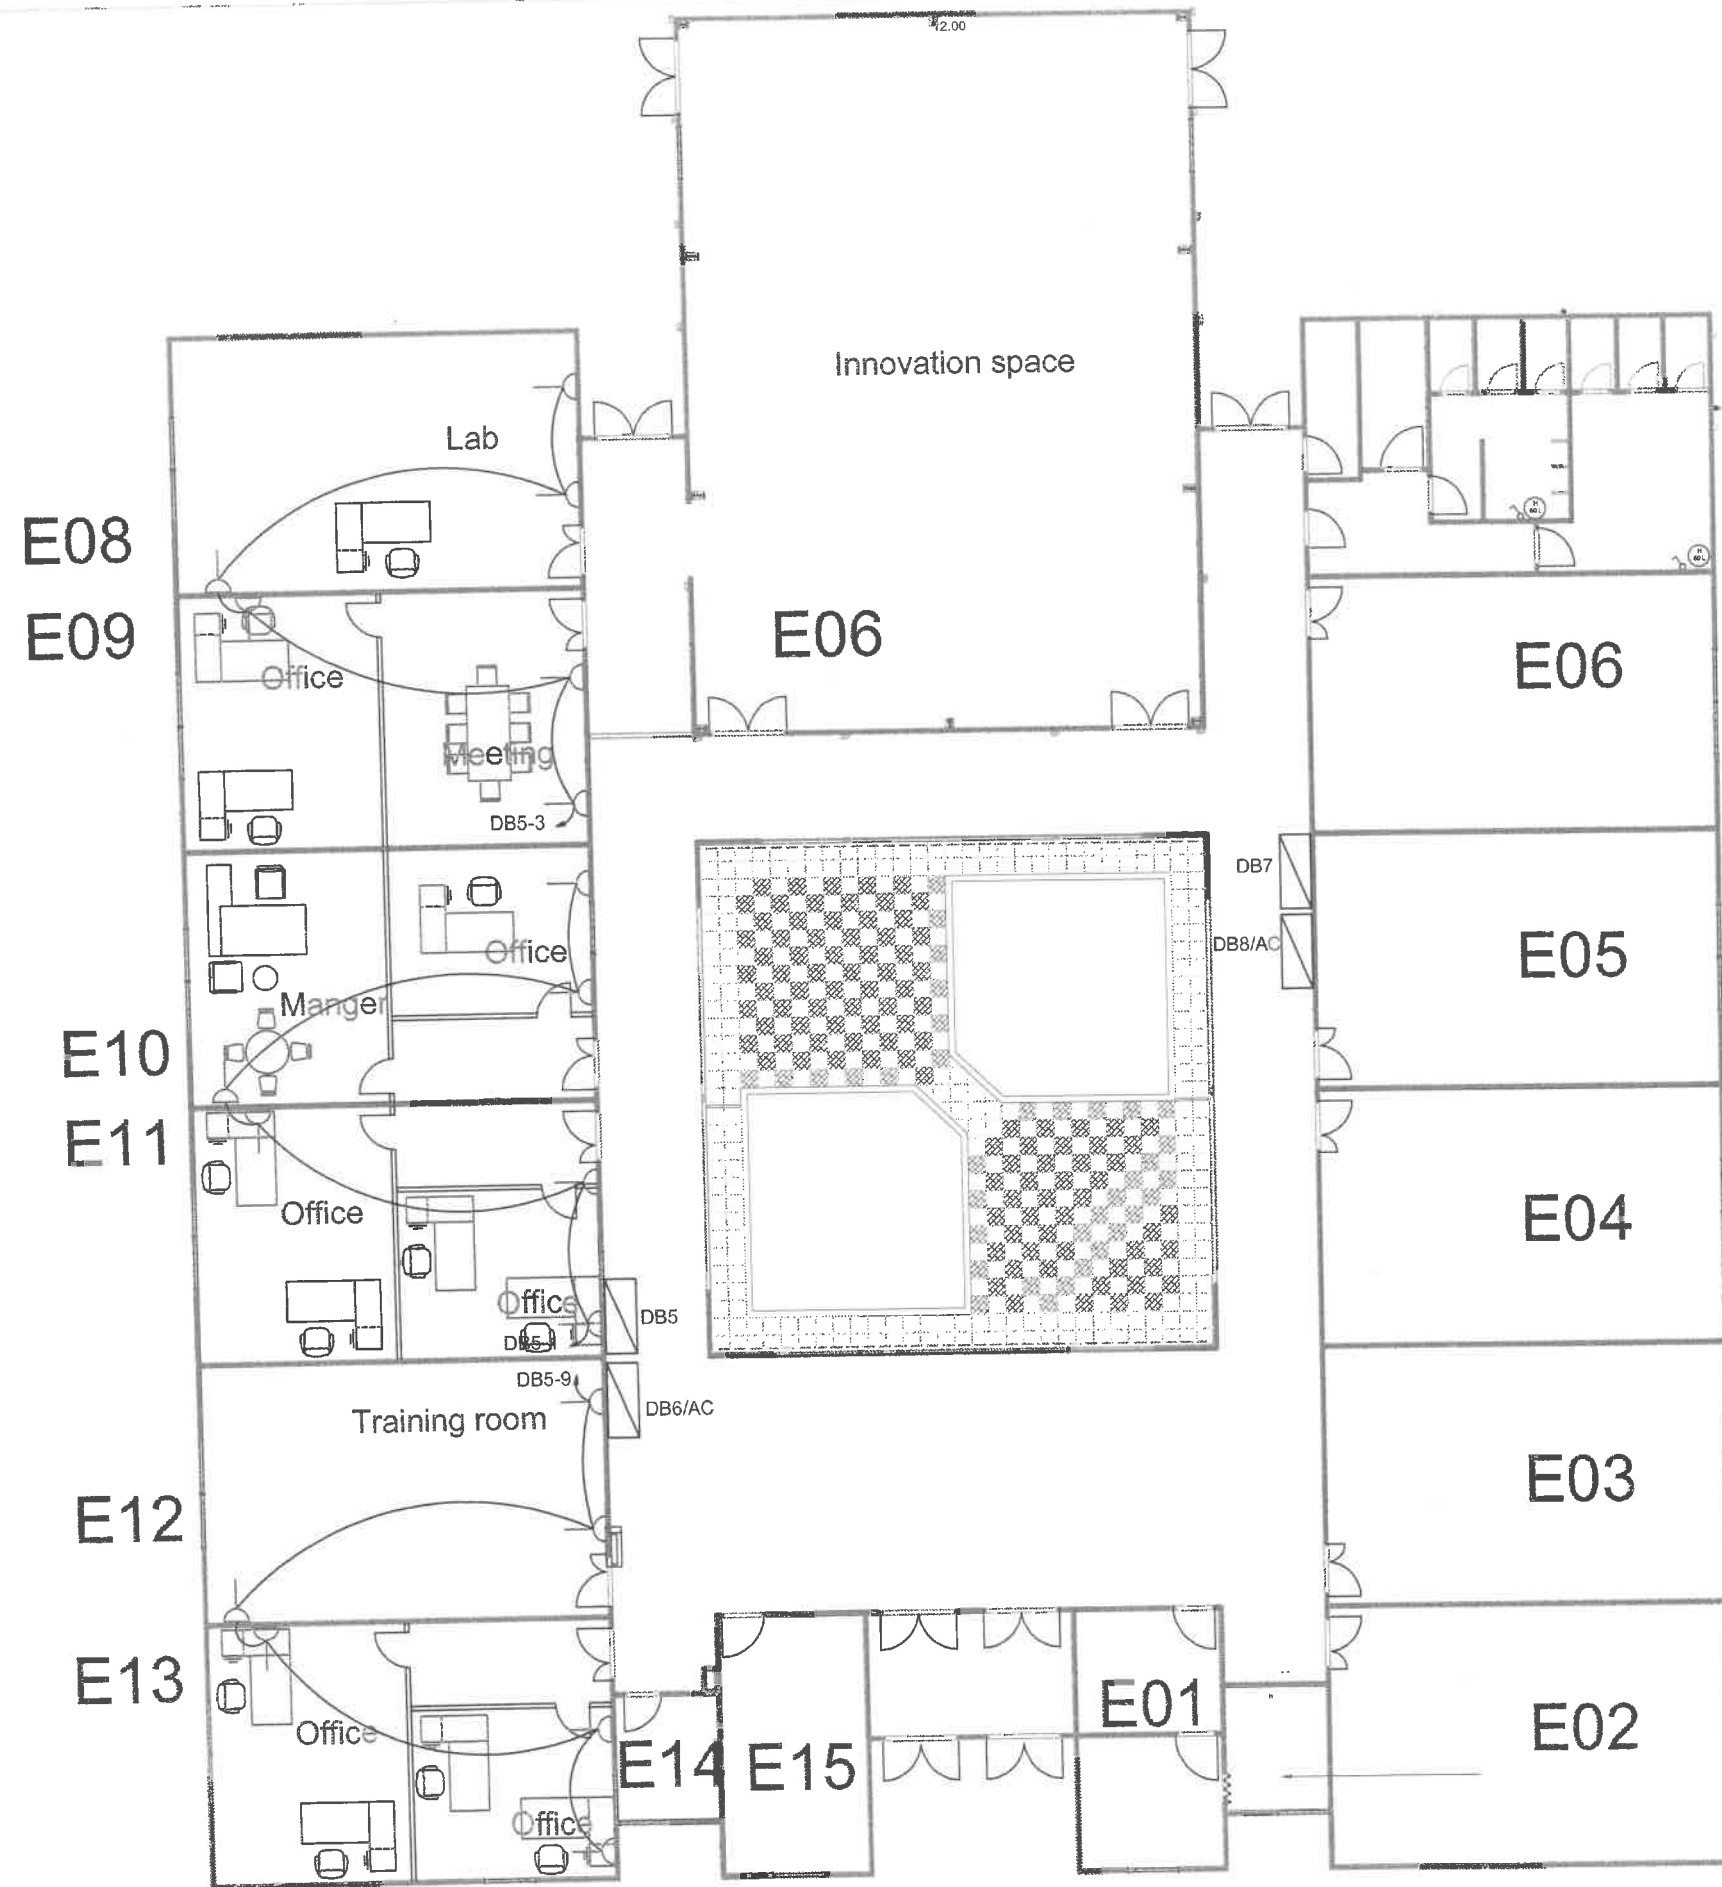

As-Built Drawing socket outlets

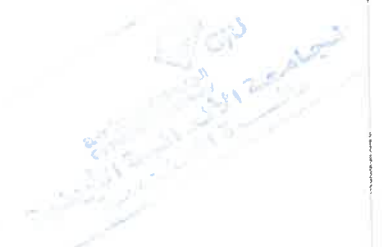


PRODUCED BY AN AUTODESK STUDENT VERSION

PRODUCED BY AN AUTODESK STUDENT VERSION

KEY PLAN	Client	Consultant
		German Jordanian University
	AMMAN - JORDAN	

PREFAB E	Scale	E01
	N.T.S	

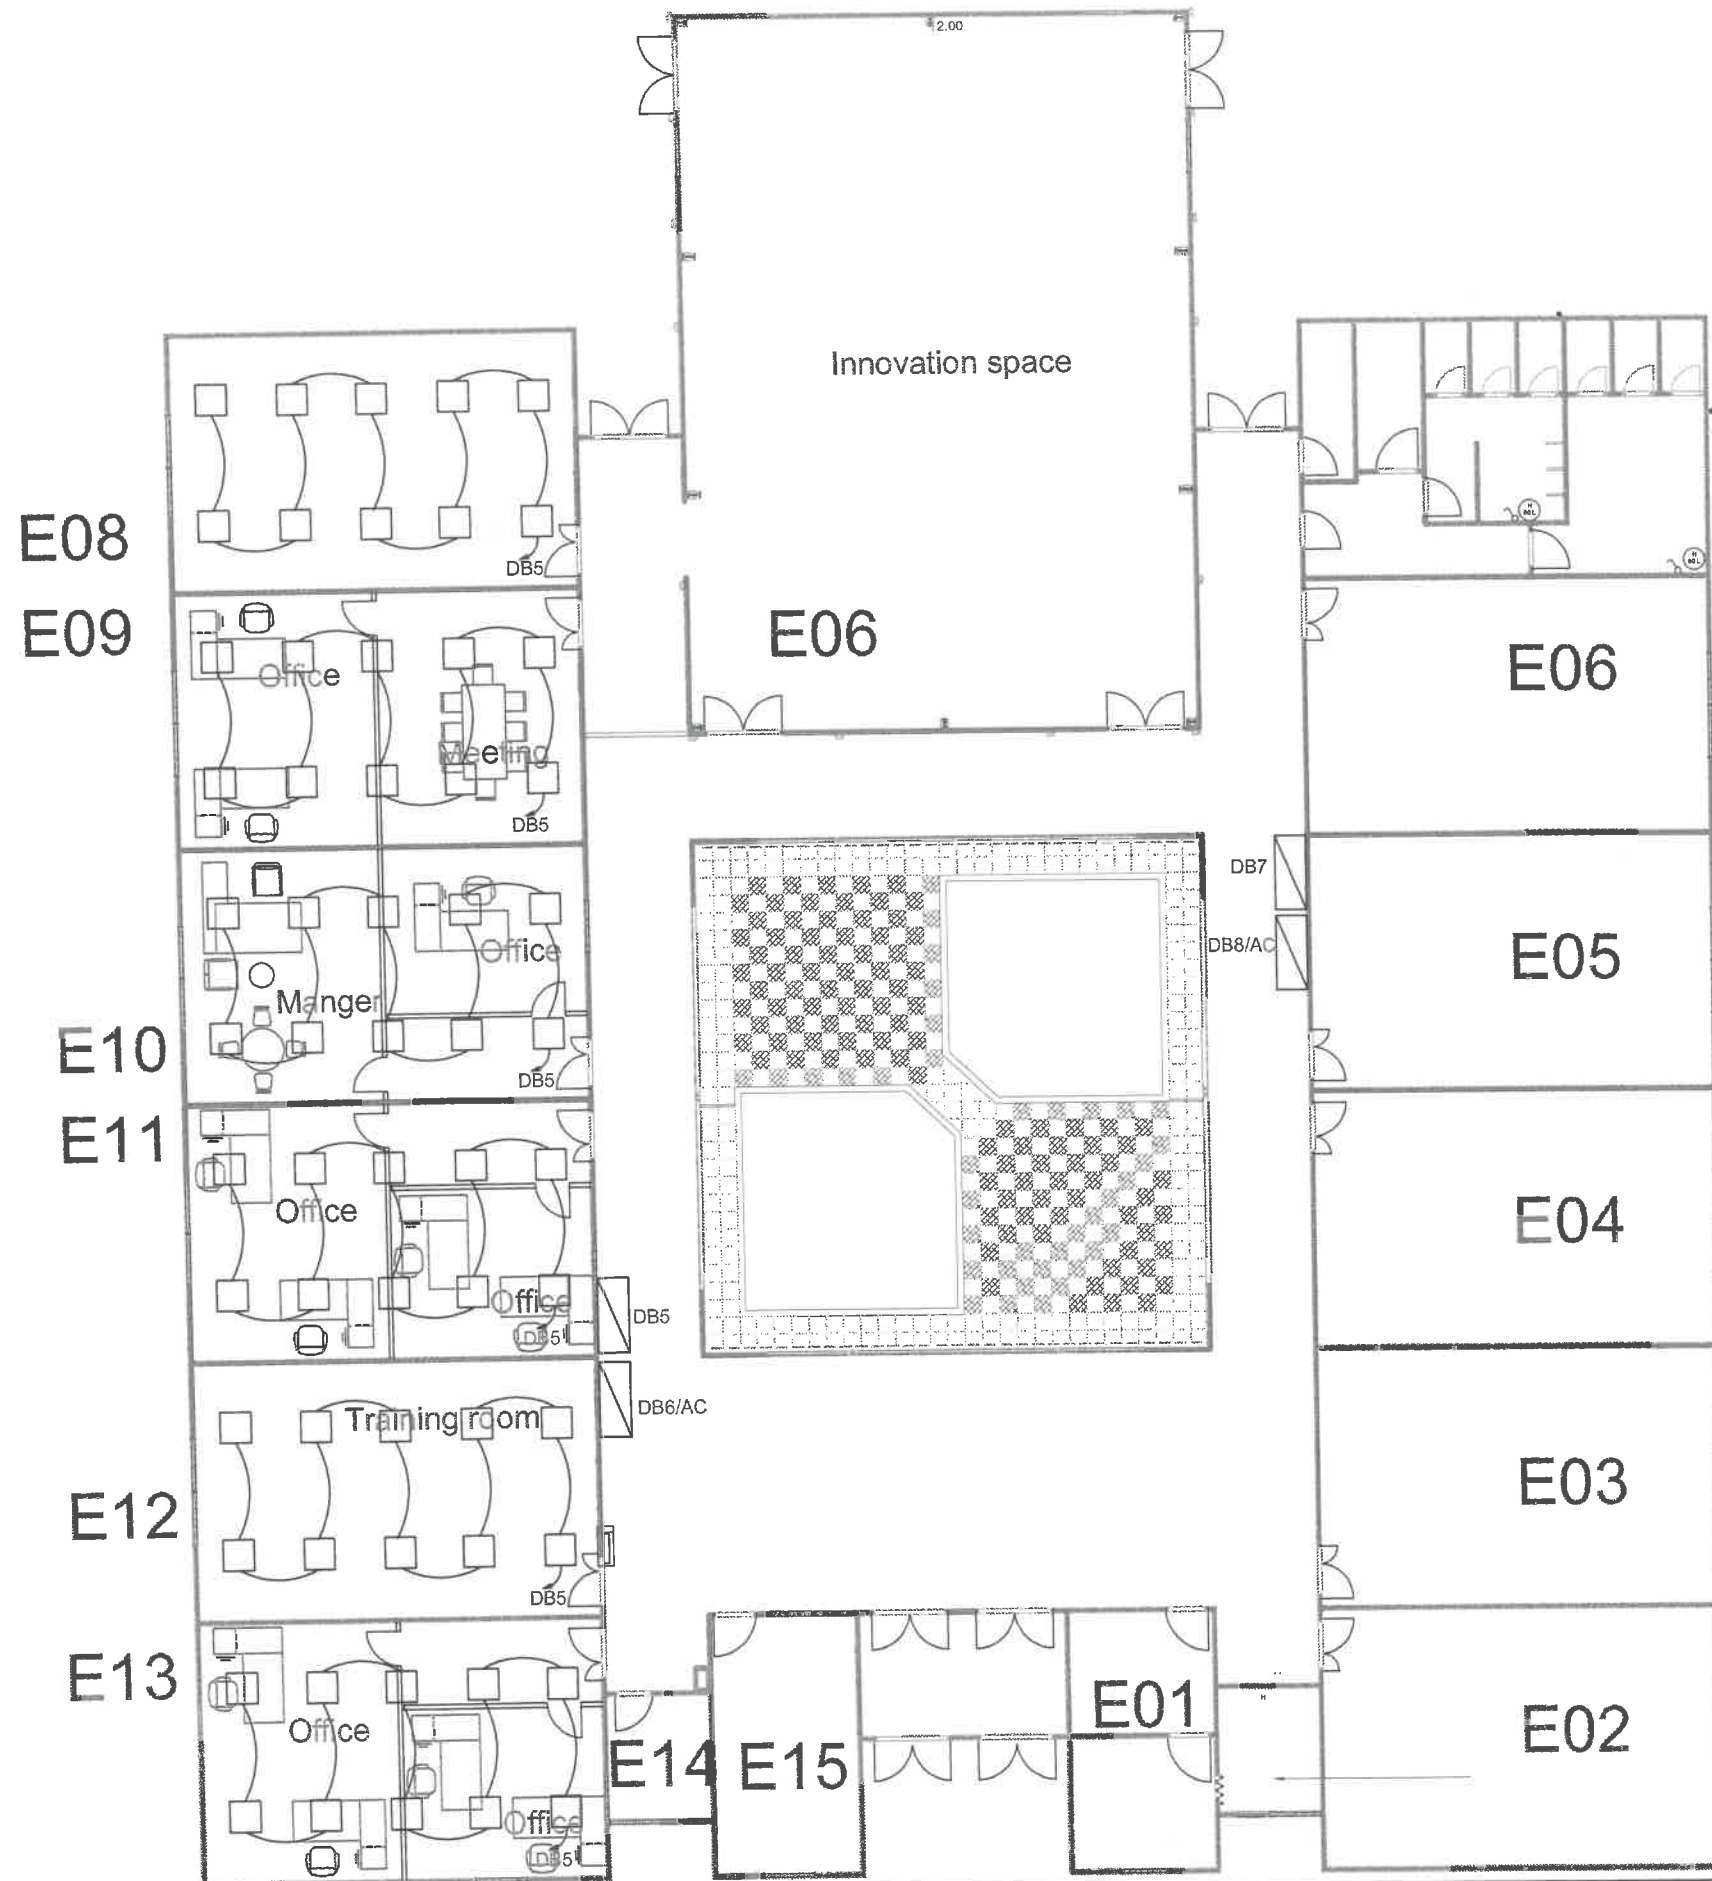

As-Built Drawing Lighting fixtures

PRODUCED BY AN AUTODESK STUDENT VERSION

PRODUCED BY AN AUTODESK STUDENT VERSION

KEY PLAN



Client



Consultant


German Jordanian University
AMMAN - JORDAN

PREFAB E

Scale

N.T.S

E02

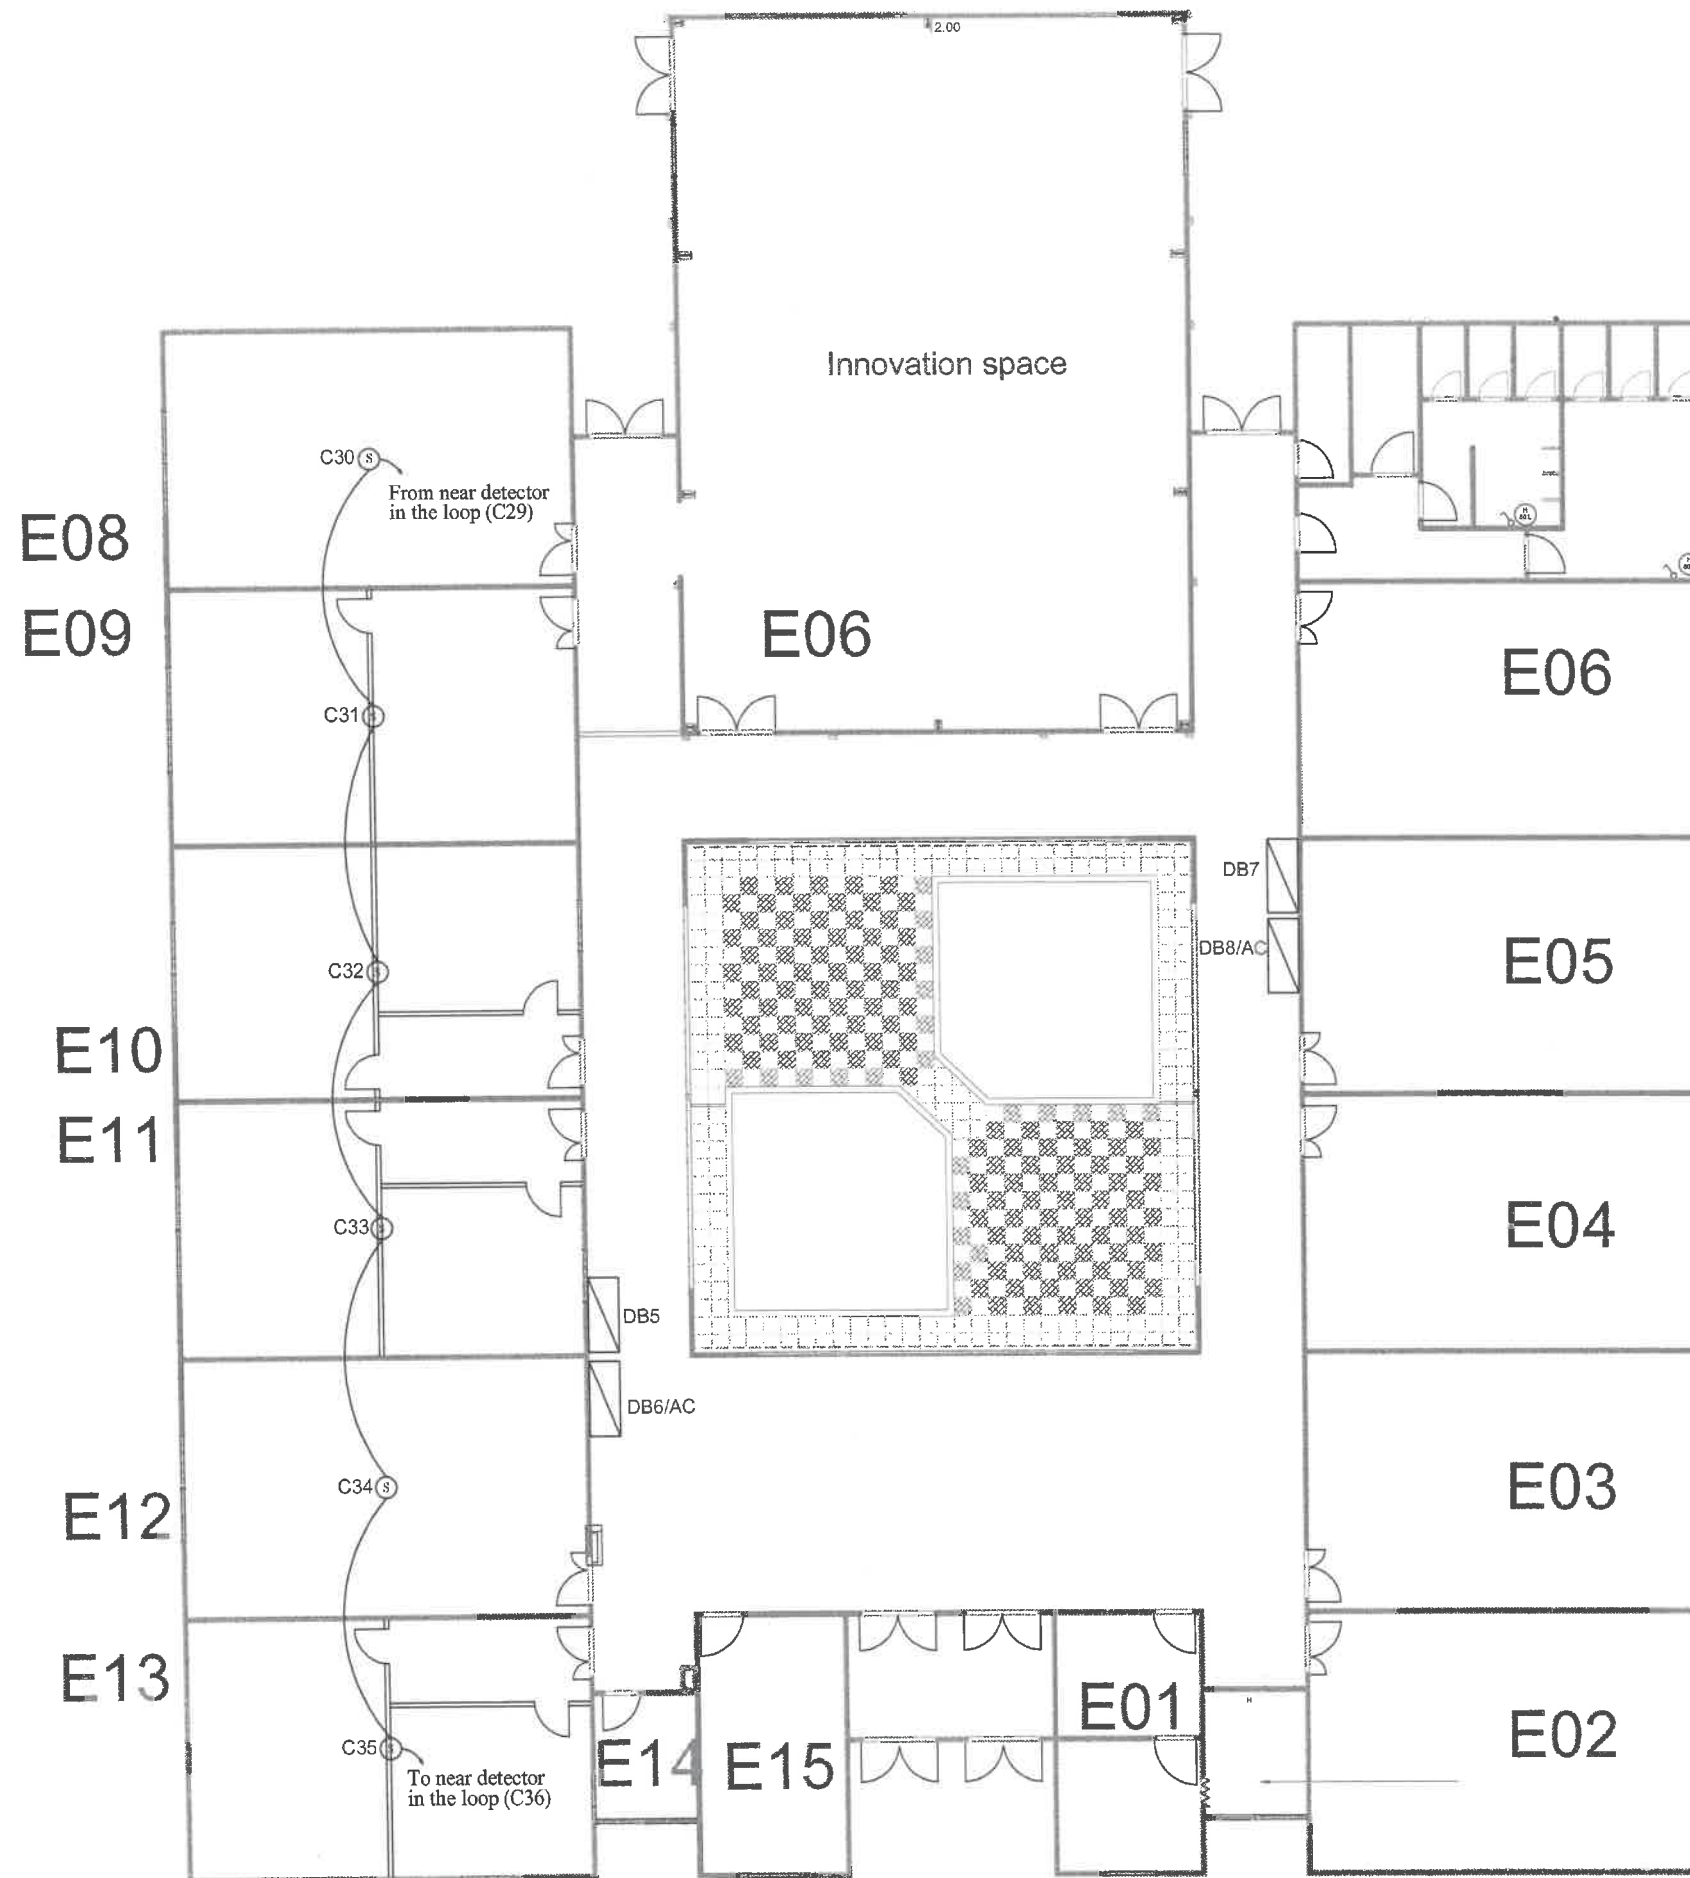

As-built Drawing Fire Alarm system

PRODUCED BY AN AUTODESK STUDENT VERSION

PRODUCED BY AN AUTODESK STUDENT VERSION




Client
GJU
 الجامعة الألمانية الأردنية
 German Jordanian University
 AMMAN - JORDAN

Consultant
 German Jordanian University
 AMMAN - JORDAN

PREFAB E

Scale
N.T.S


E03

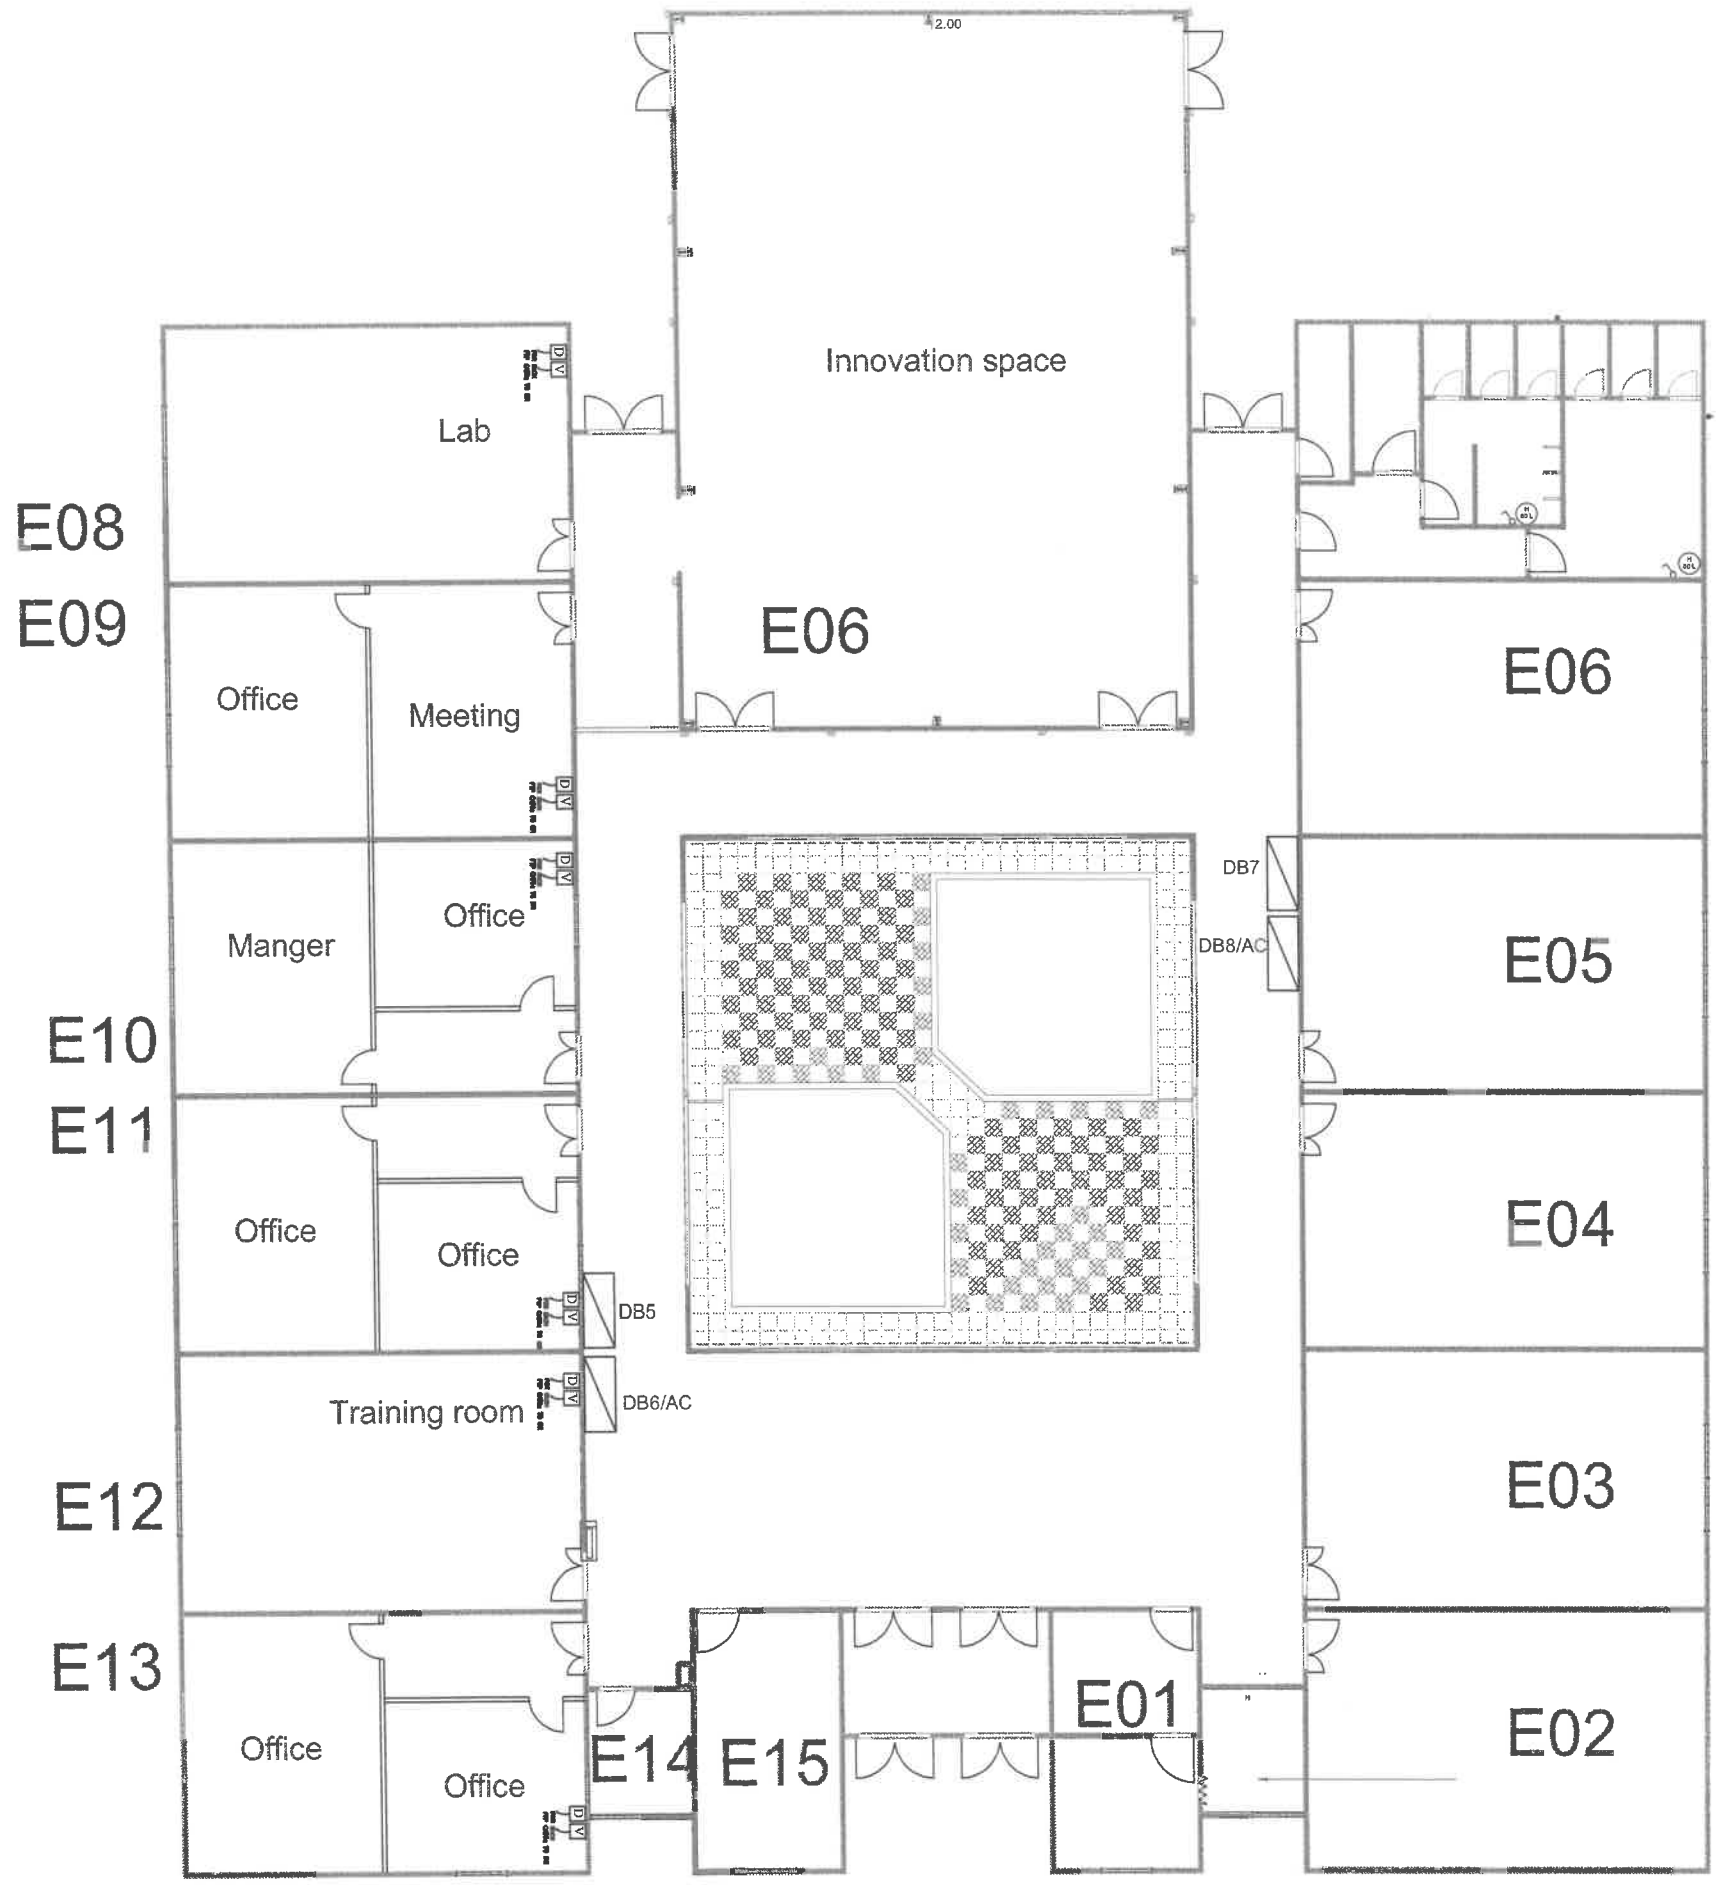


As-built Drawing Data and Voice system

PRODUCED BY AN AUTODESK STUDENT VERSION

PRODUCED BY AN AUTODESK STUDENT VERSION

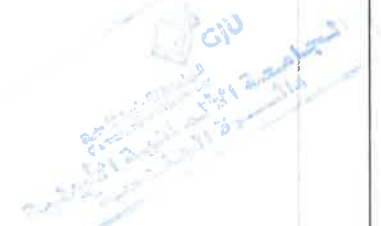

<p>KEY PLAN</p> 	<p>Client</p>  <p>الجامعة الألمانية الأردنية German Jordanian University</p>	<p>Consultant</p> <p>German Jordanian University AMMAN - JORDAN</p>	<p>PREFAB E</p>	<p>Scale</p> <p>N.T.S</p>	<p>E04</p>
---	---	---	-----------------	---------------------------	------------

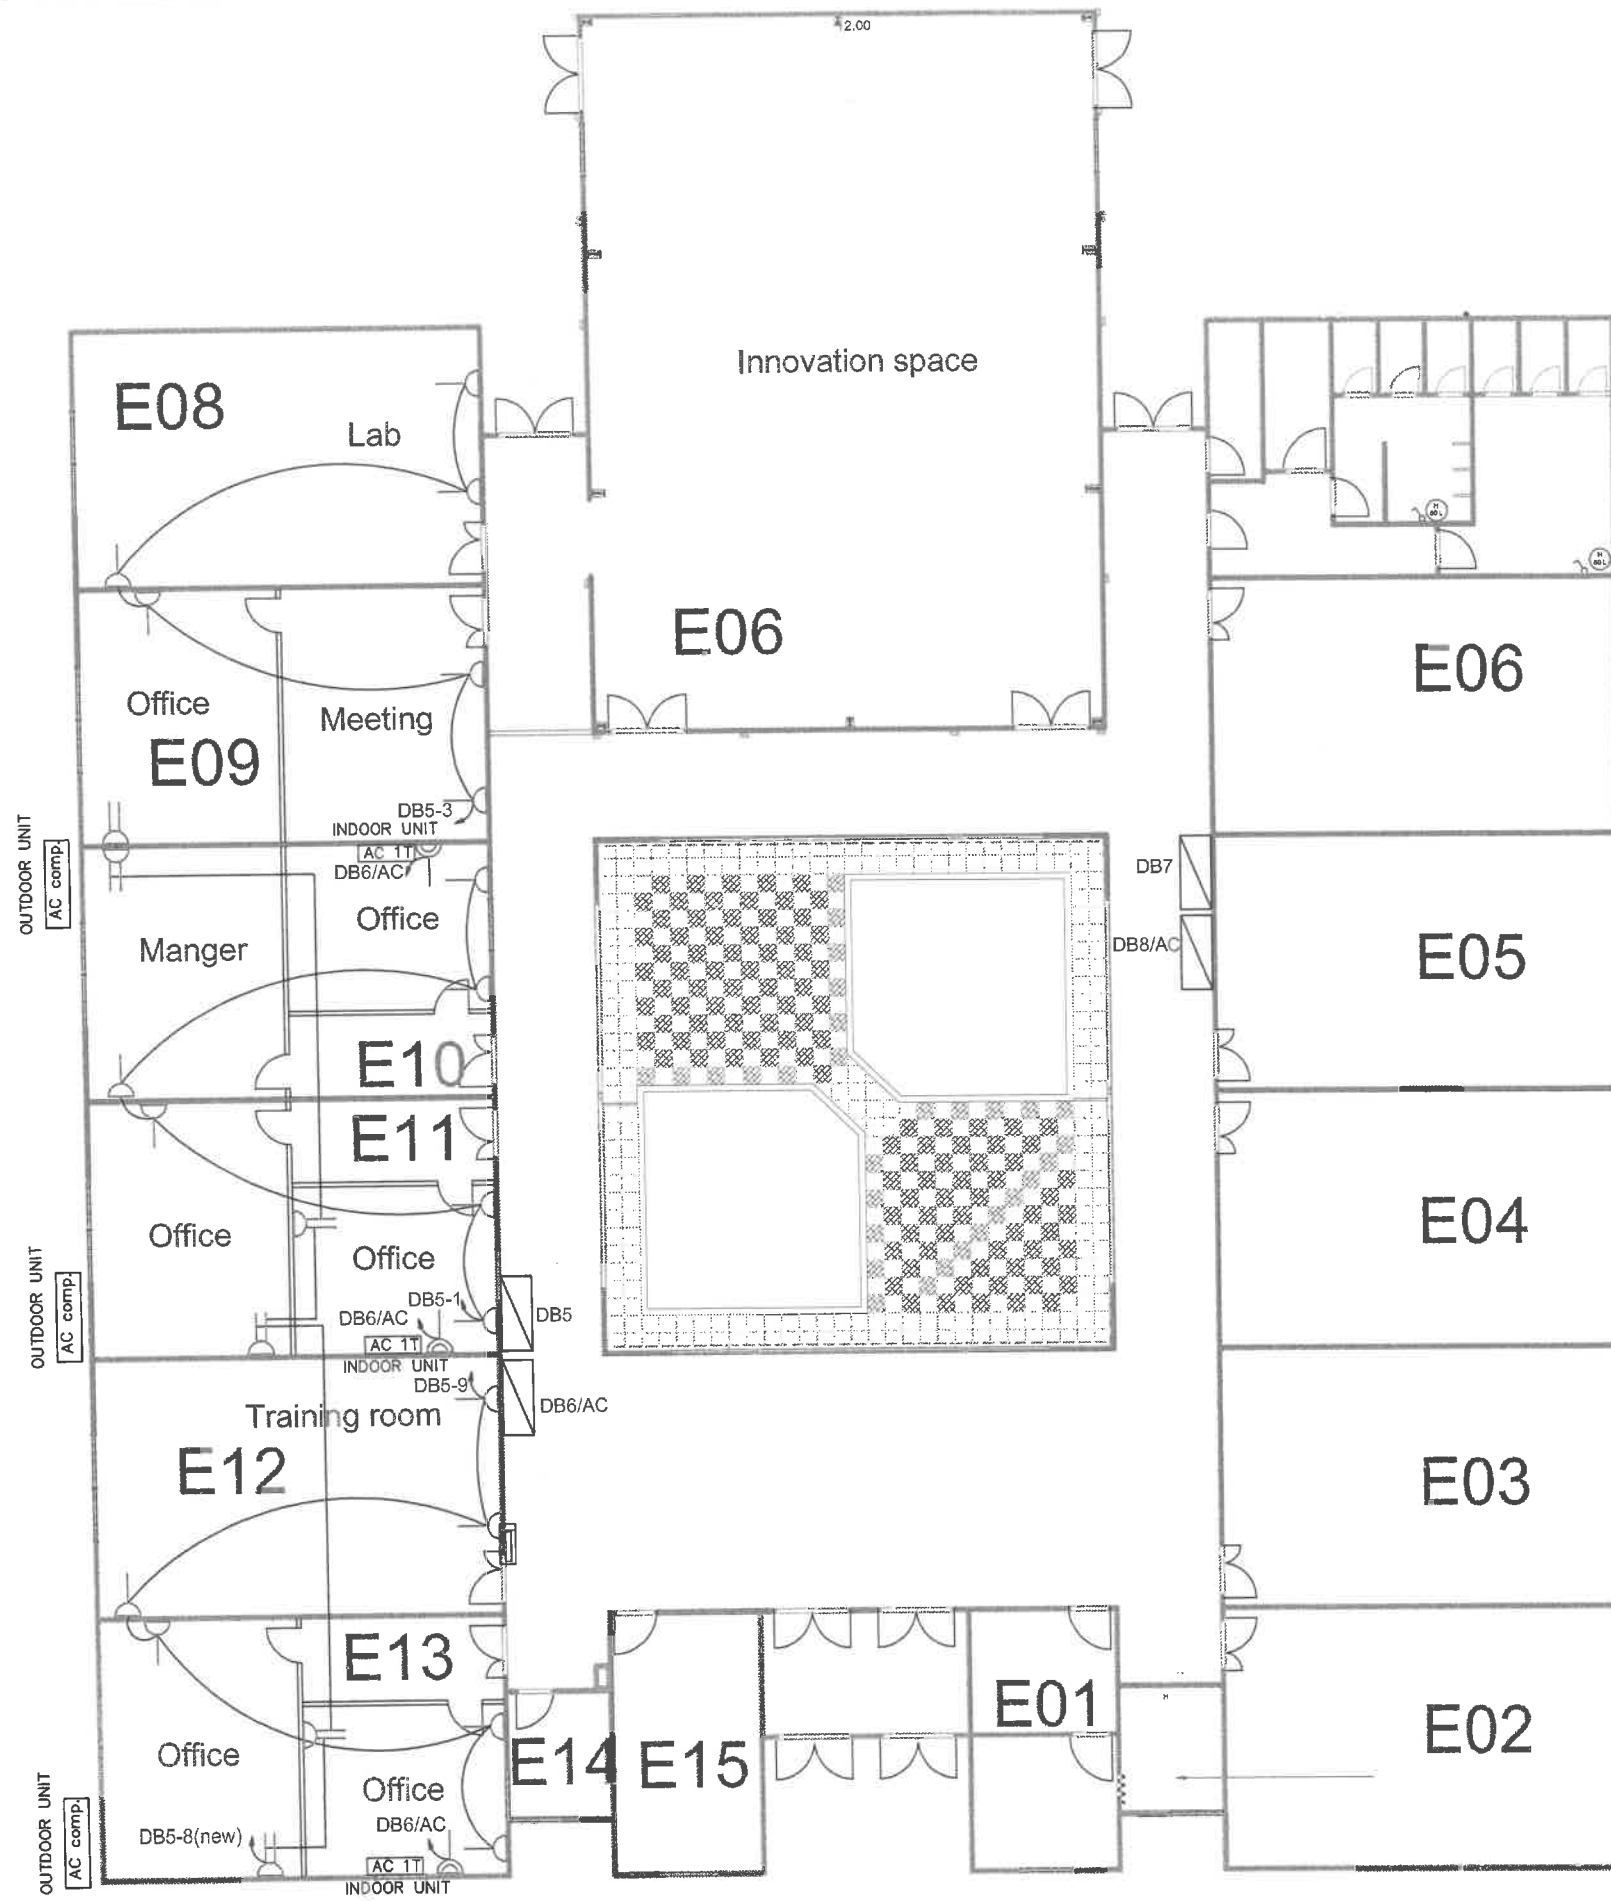

Drawing with additional sockets


Handwritten text in Arabic, likely a signature or stamp, located in the lower right quadrant of the drawing area.

PRODUCED BY AN AUTODESK STUDENT VERSION


PRODUCED BY AN AUTODESK STUDENT VERSION

KEY PLAN	Client	Consultant
		German Jordanian University AMMAN - JORDAN

PREFAB E	Scale	E05
	N.T.S	

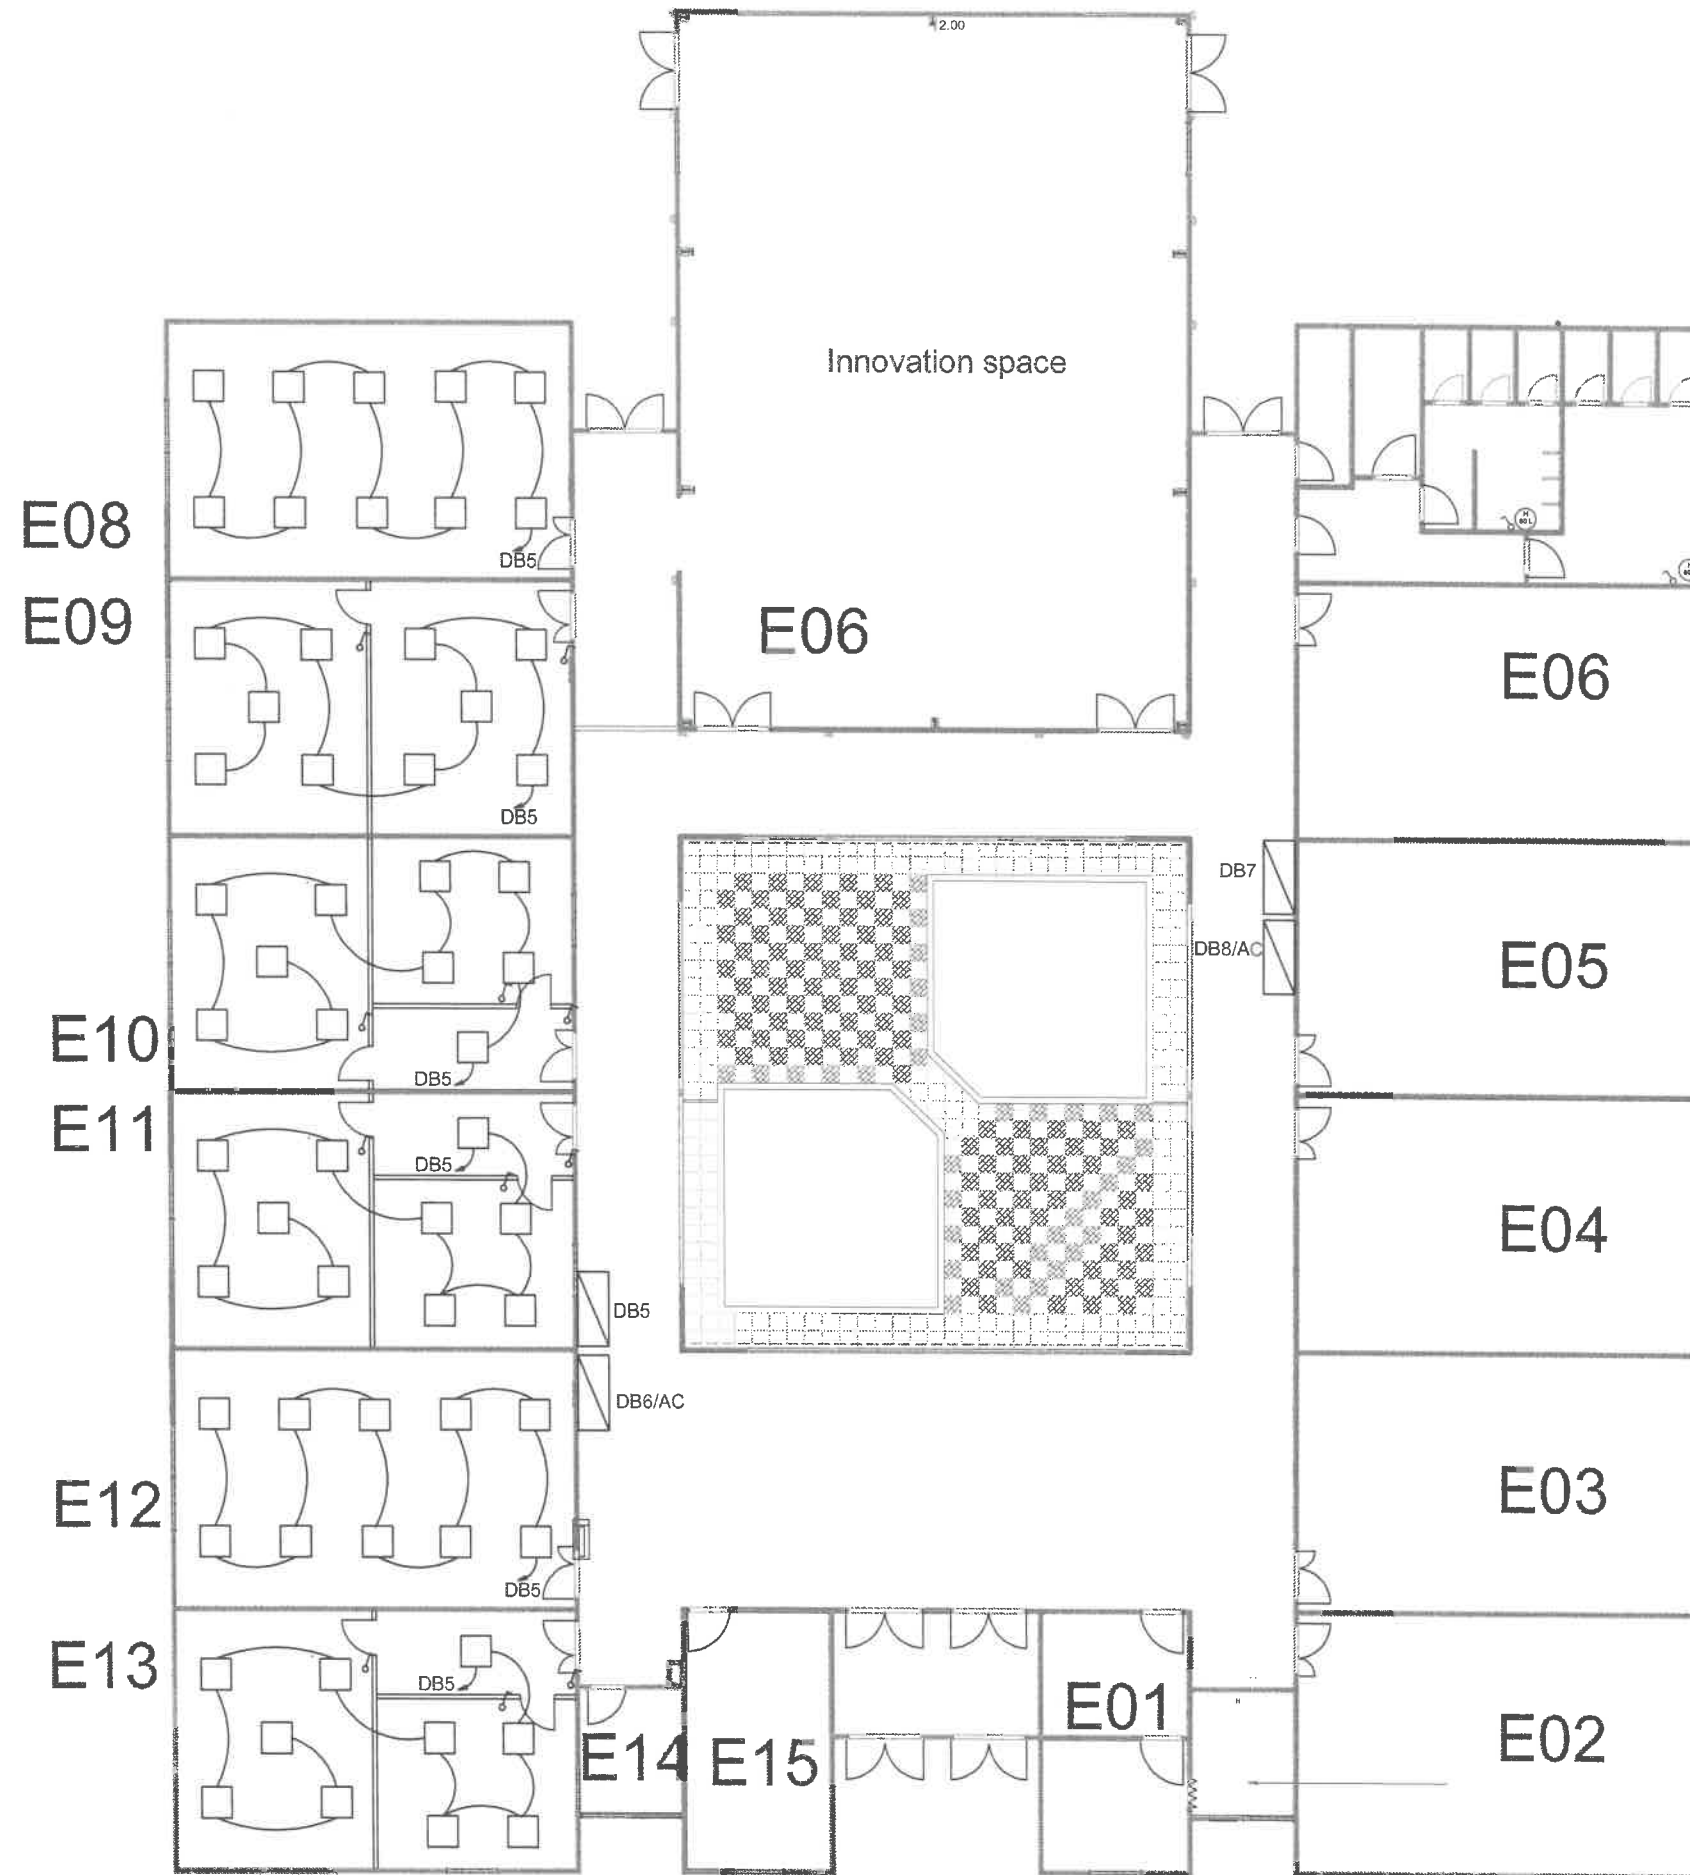


Redesign lighting fixture

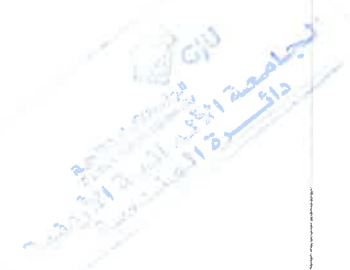

Client
GJU
 الجامعة الألمانية الأردنية
 German Jordanian University
 AMMAN - JORDAN

Consultant
 German Jordanian
 University
 AMMAN - JORDAN



PREFAB E	Scale N.T.S	E06
----------	----------------	-----

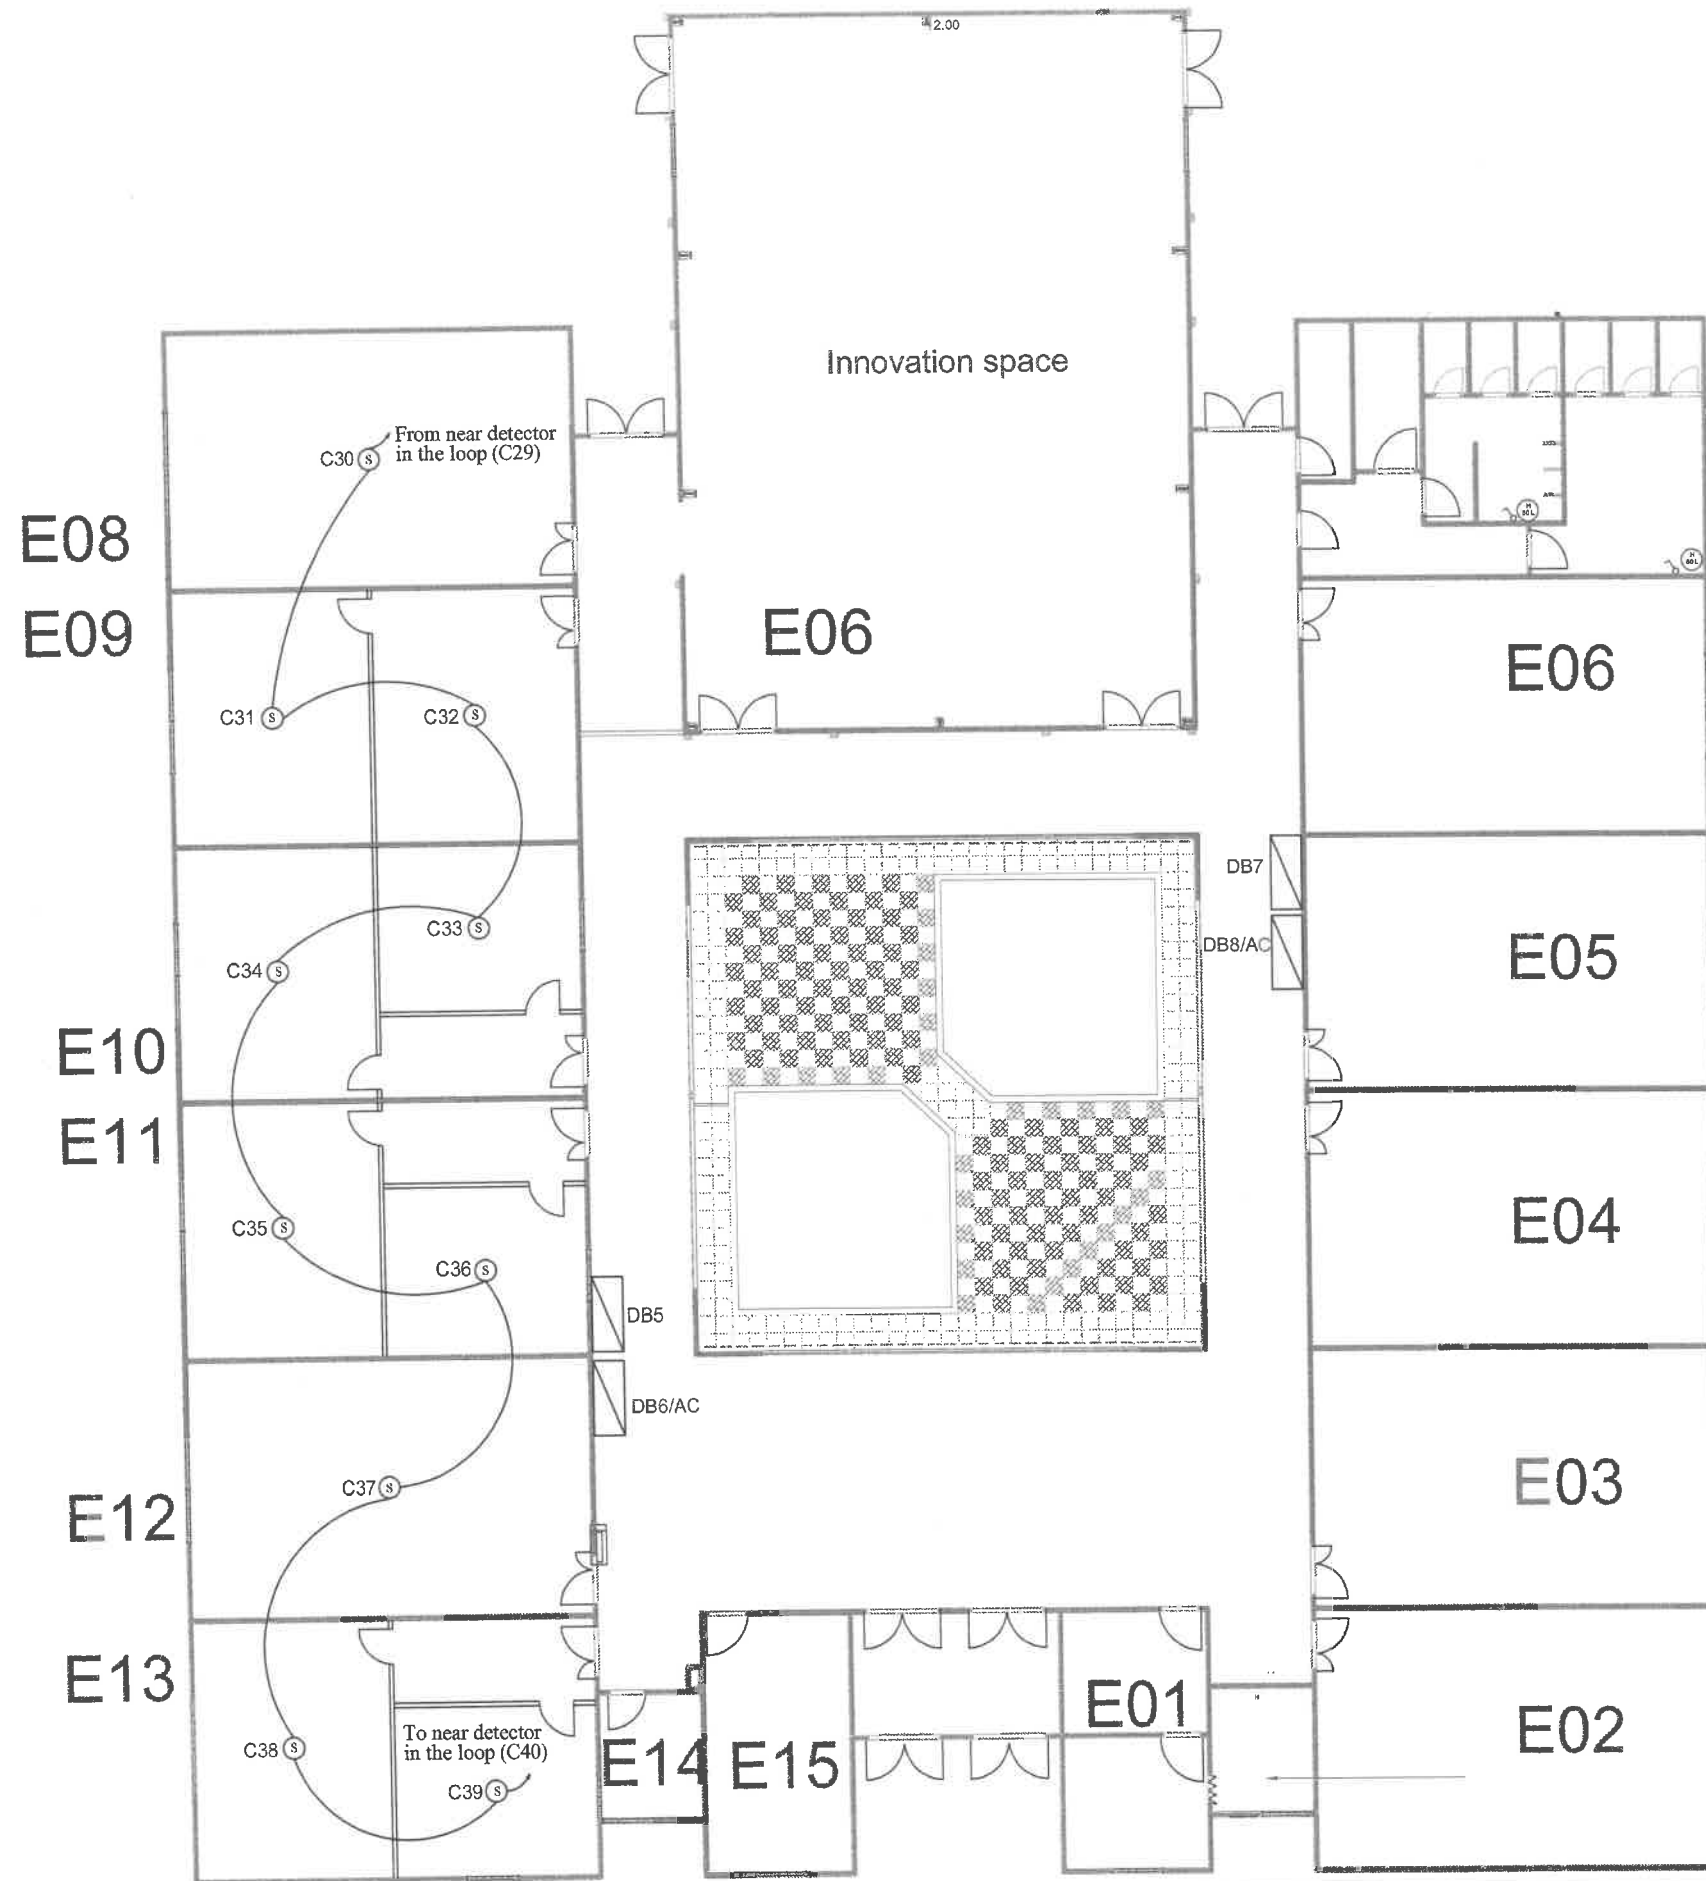

Drawing with additional detectors

PRODUCED BY AN AUTODESK STUDENT VERSION

 
PRODUCED BY AN AUTODESK STUDENT VERSION

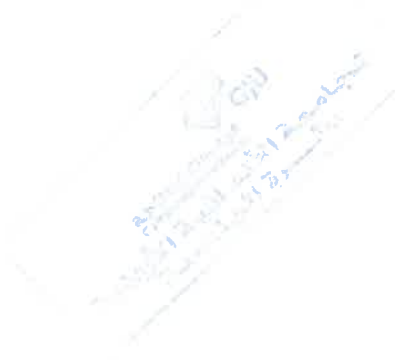

Client
 GJU
 الجامعة الألمانية الأردنية
 German Jordanian University
 AMMAN - JORDAN

Consultant
 German Jordanian University
 AMMAN - JORDAN

PREFAB E	Scale N.T.S	E07
----------	----------------	-----

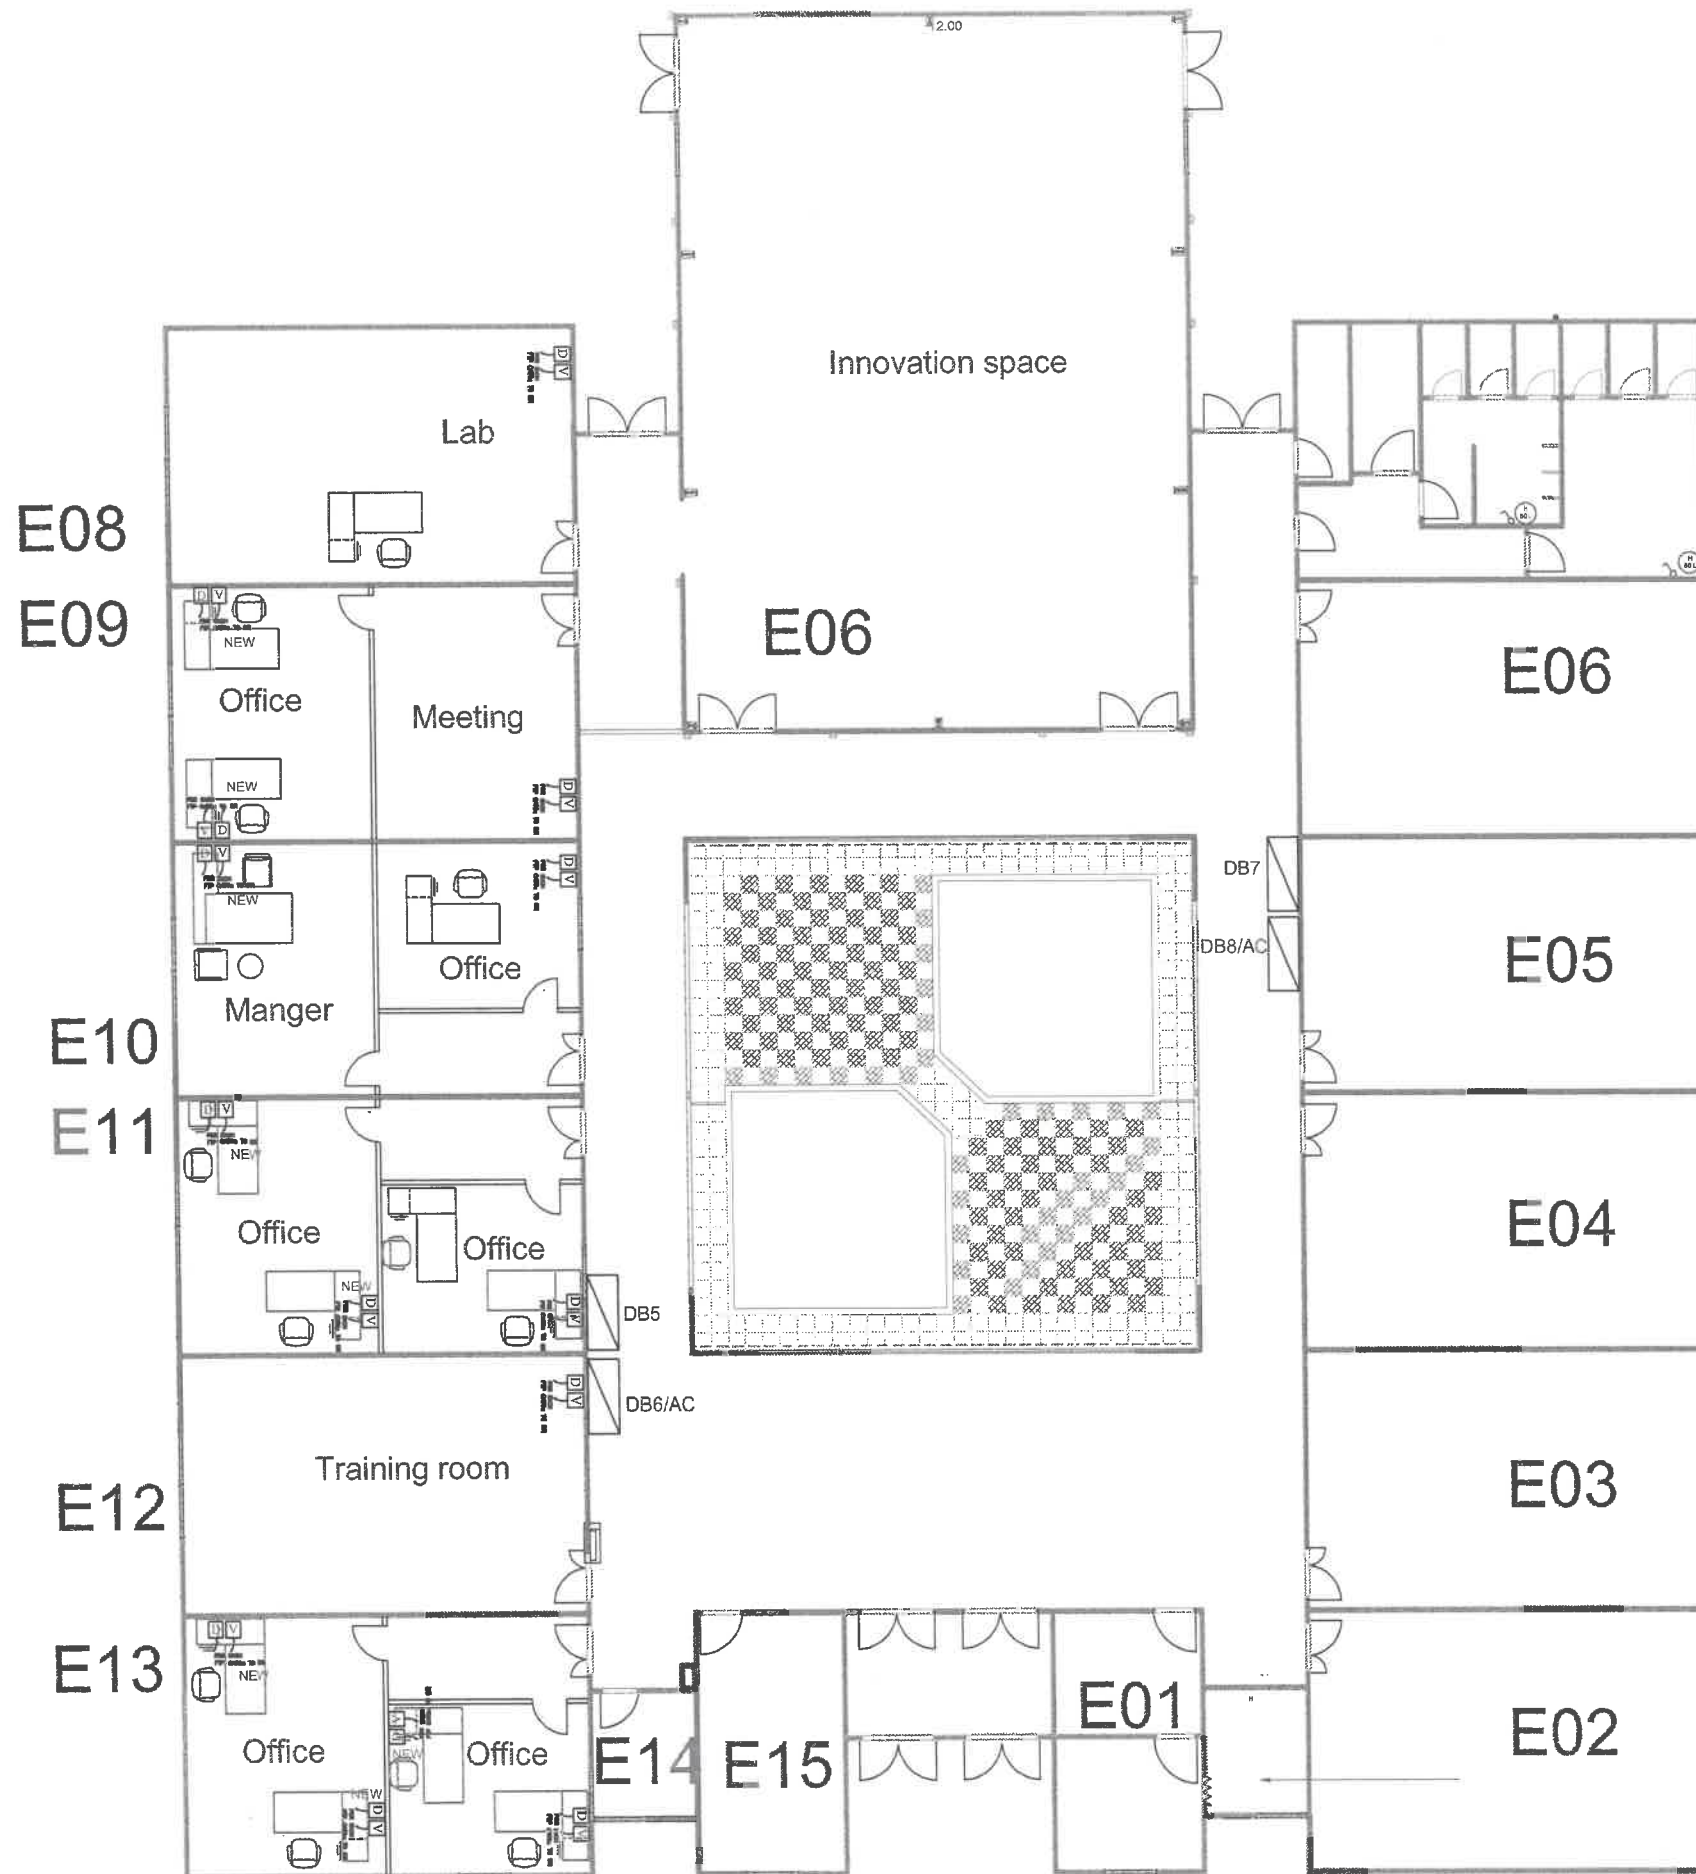

Drawing with additional data and voice sockets

PRODUCED BY AN AUTODESK STUDENT VERSION


PRODUCED BY AN AUTODESK STUDENT VERSION



Client
GJU
 الجامعة الألمانية الأردنية
 German Jordanian University

Consultant
 German Jordanian University
 AMMAN - JORDAN

PREFAB E	Scale N.T.S	E08
----------	----------------	-----

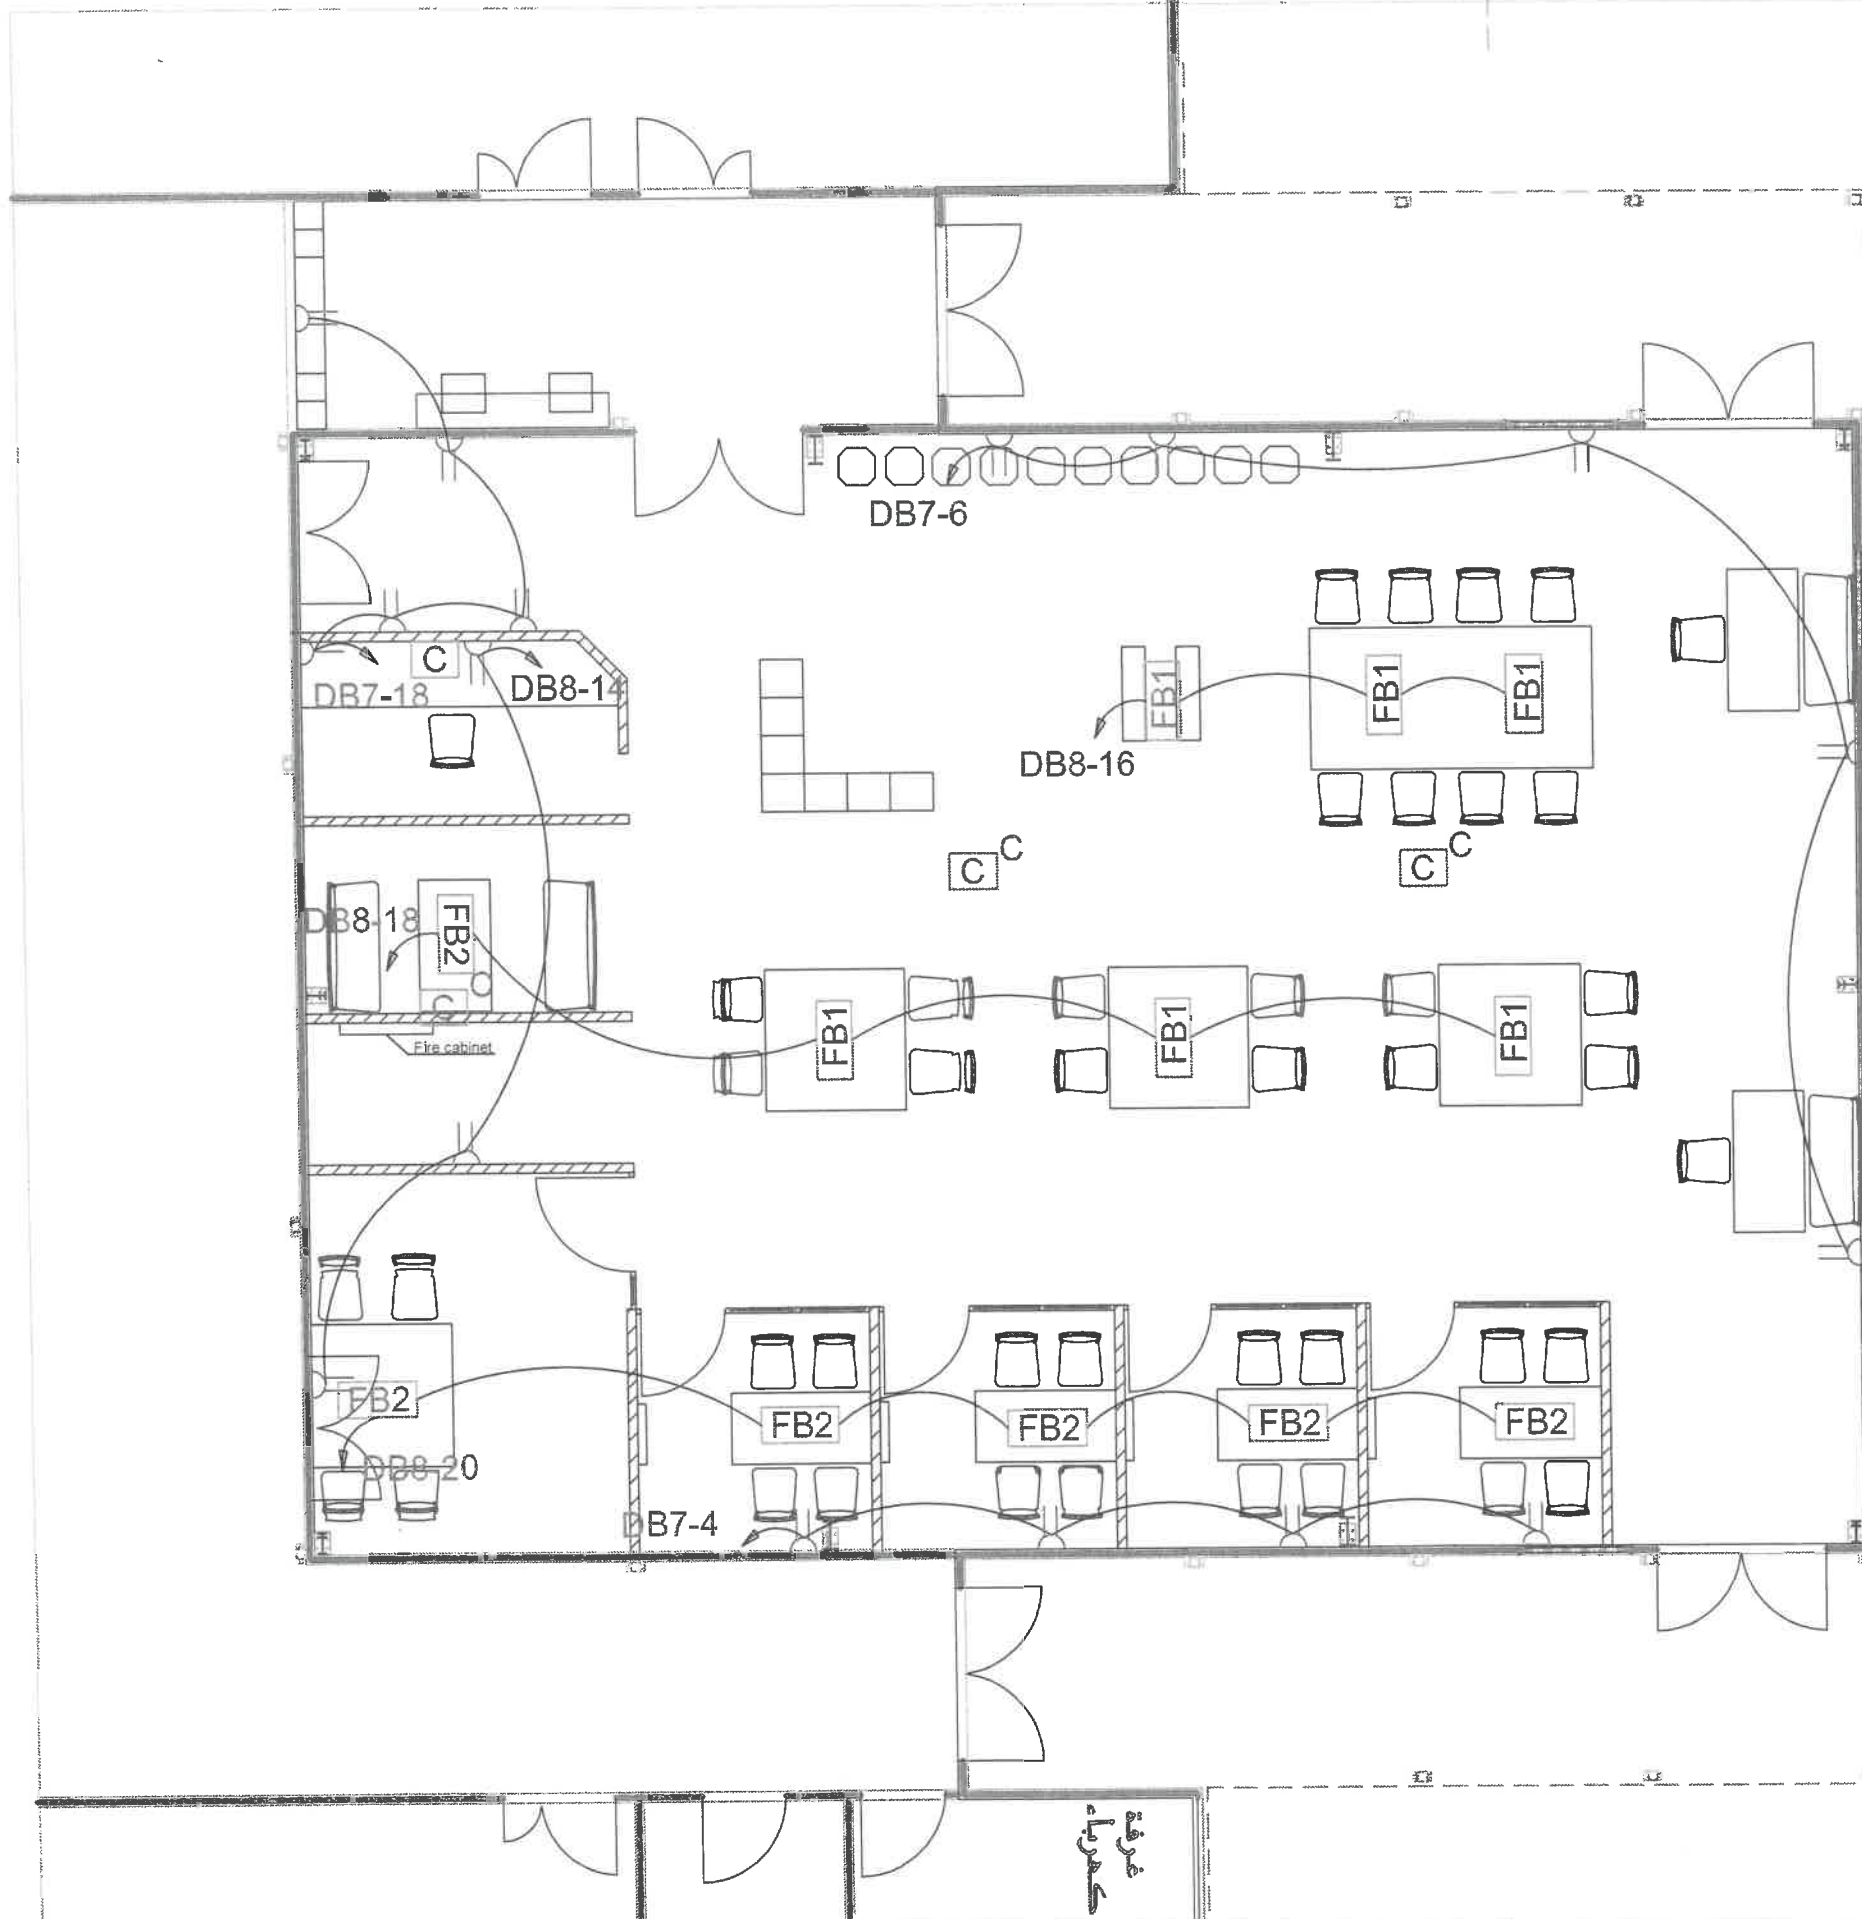

LEGEND :


- 3 PIN, 230 V, 13A SWITCH SOCKET OUTLET
- 3 PIN, 230 V, 13A SWITCH SOCKET DOUBLEX
- Floor Data Point
- Floor Data Point
- Ceiling Data Point



Client
GJU
 الجامعة الألمانية الأردنية
 German Jordanian University
 AMMAN - JORDAN




Consultant
 German Jordanian
 University
 AMMAN - JORDAN

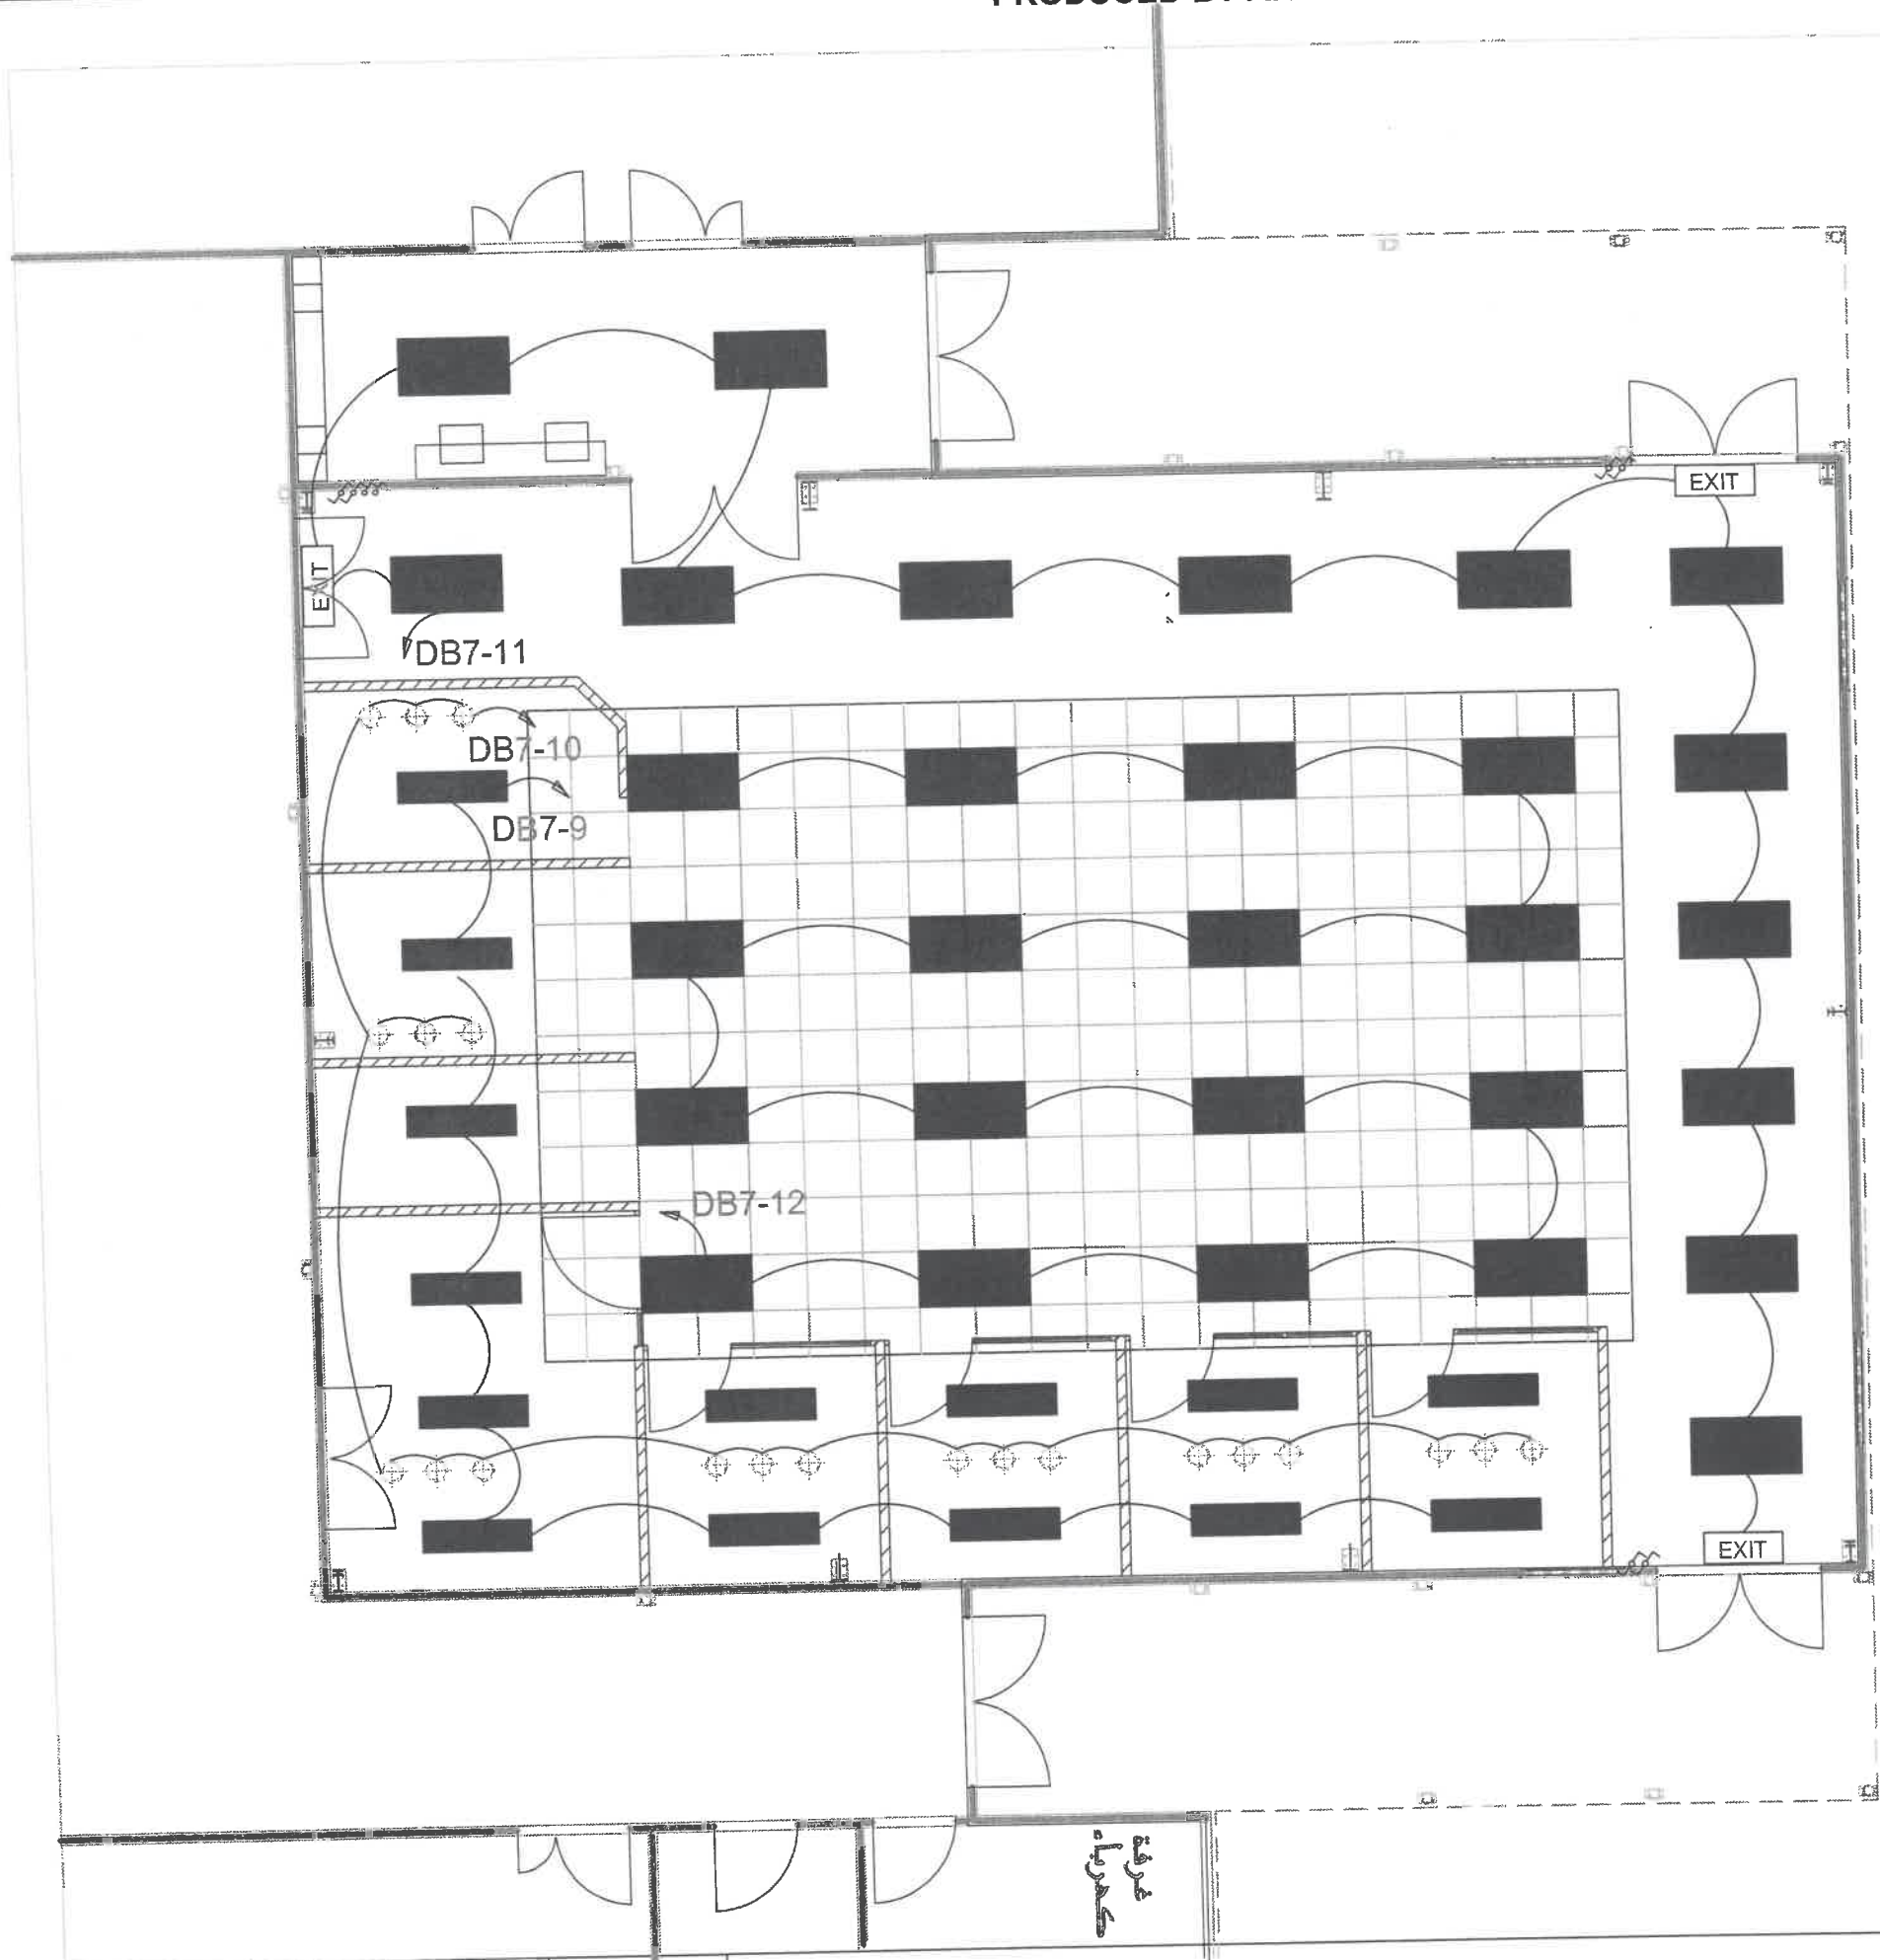PREFAB E
 Innovation space
 Scale
 N.T.S
 E09



جامعة الألمانية الأردنية
 German Jordanian University
 AMMAN - JORDAN

LEGEND :

-  Led Recessed Modular Light 75W, 9750 Lm, IP 44
-  Led Recessed Modular Light 36W, 4680 Lm, IP 44
-  Decorative suspended LED light

KEY PLAN 

Client  German Jordanian University
 الجامعة الألمانية الأردنية
 German Jordanian University

Consultant  German Jordanian University
 AMMAN - JORDAN

PREFAB E Innovation space	Scale N.T.S	E10
------------------------------	----------------	-----